



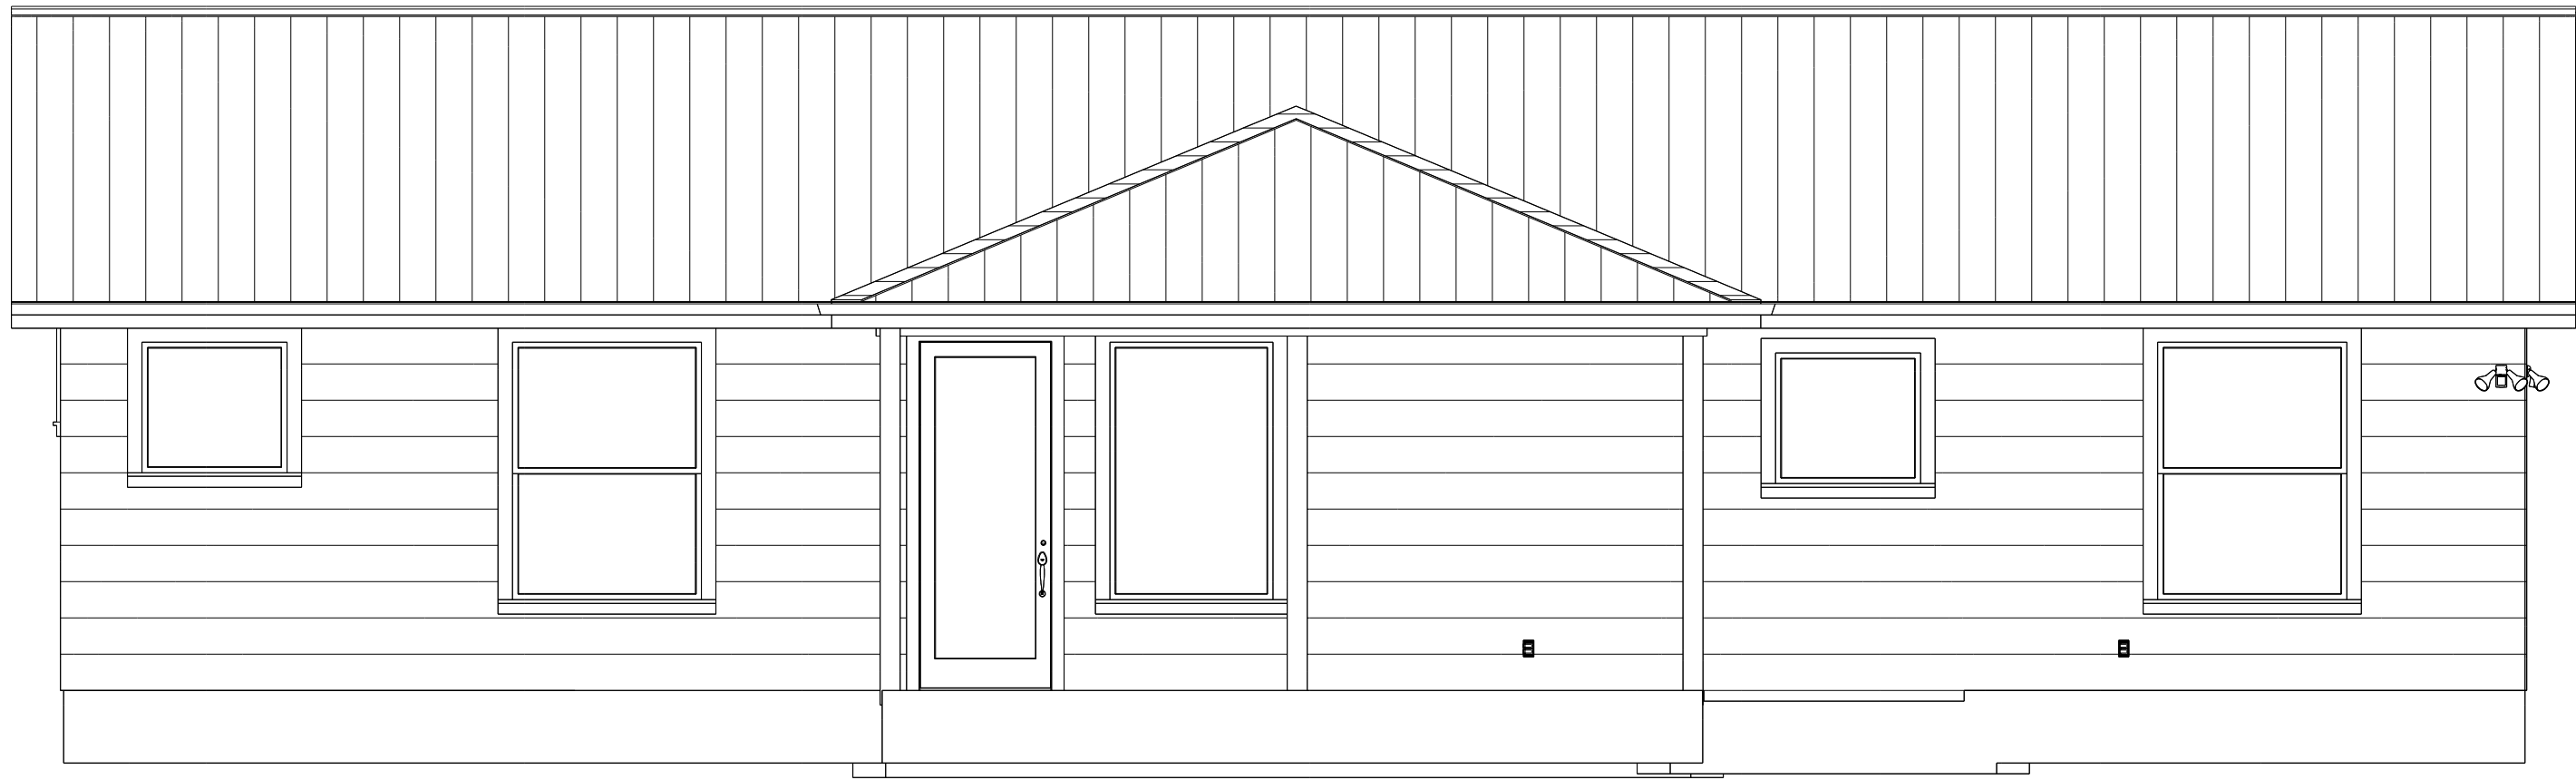

FRONT VIEW

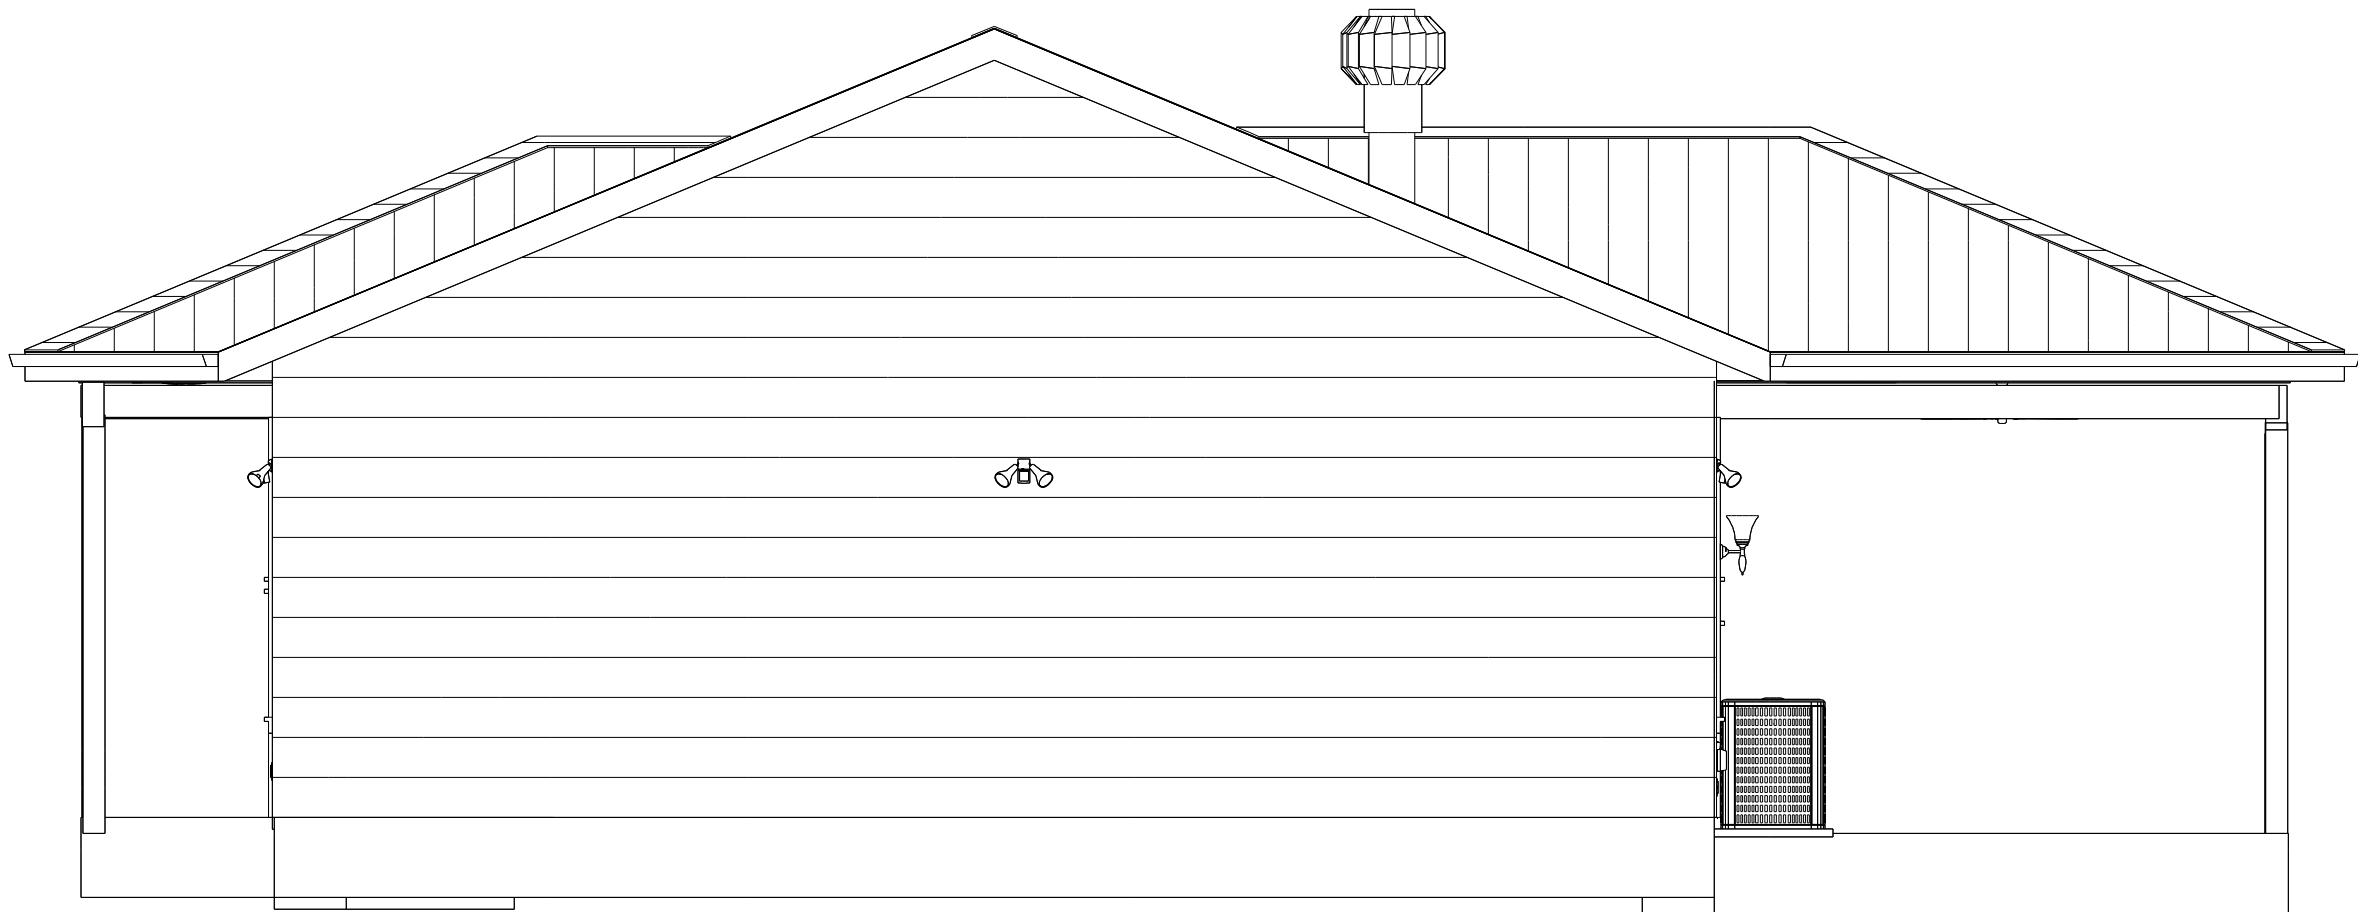

RIGHT END

STANDARD INFO:

2 X 6 WOOD FRAME EXT. WALLS
2 X 4 INTERIOR WALLS WOOD
SHEATHING
ON WALL SECTIONS AND ROOF 7/16
OSB PANELS
ROOF 6/12 PITCH W/ STICKDOWN
SHEETING AND METAL ROOF PANELS
200 A ELECTRICAL SERVICE


AREA CALCS

LIVING	1710
REAR PORCH	239
FRONT PORCH	77
TOTAL	2026

area



REAR VIEW

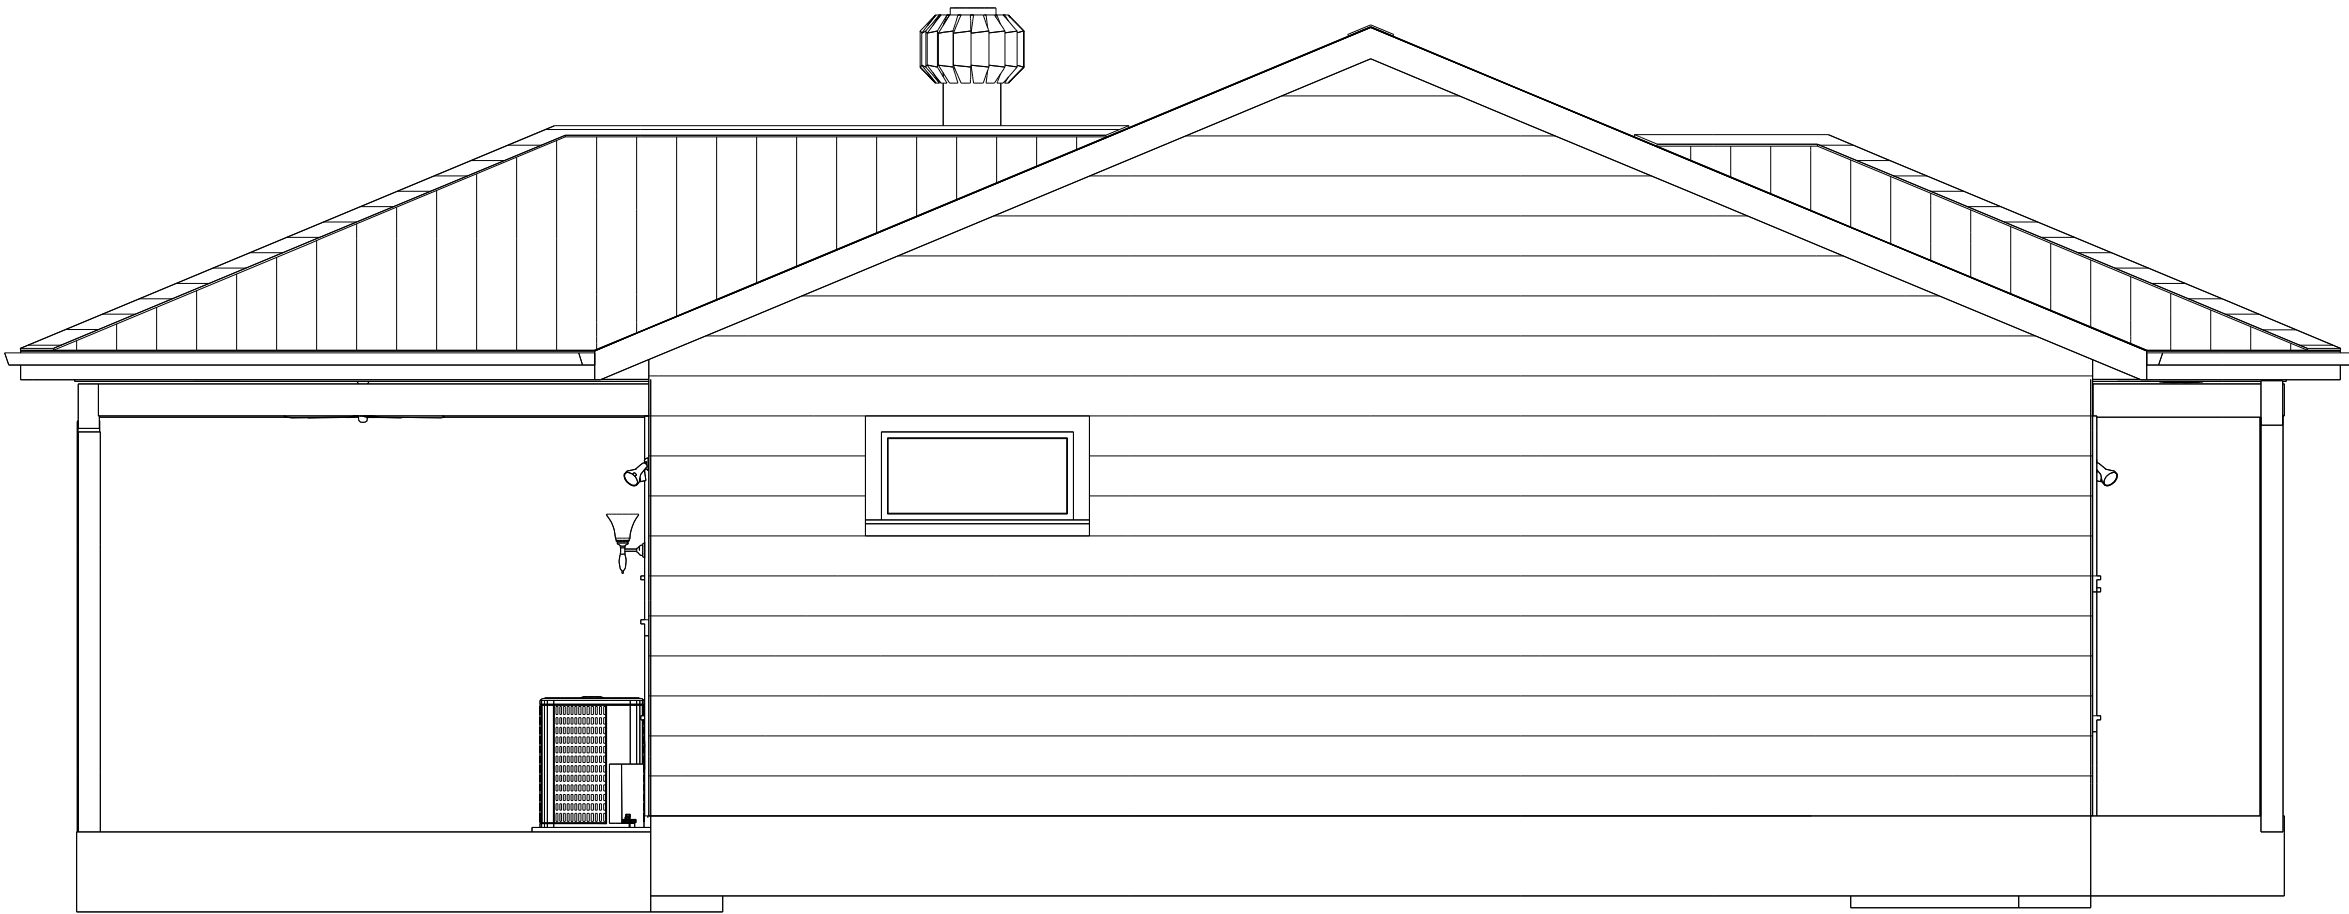


LEFT END


DOOR SCHEDULE						
NUMBER	QTY	SIZE	R/O	DESCRIPTION	HINGE	LINTEL
D01	4	2868	34"X82 1/2"	HINGED-4-PANEL	HIDDEN (2)	
D02	2	2868	66"X82 1/2"	POCKET-4-PANEL	HIDDEN (2)	
D03	1	3068	37"X81 1/2"	2 DR. BIFOLD-SLAB	HIDDEN (2)	
D04	1	3030	37"X81 1/2"	HINGED-GLASS PANEL	HIDDEN (2)	
D05	1	3030	37"X81 1/2"	EXT. HINGED-GLASS PANEL	HIDDEN (2)	
D06	1	5068	61"X81 1/2"	4 DR. BIFOLD-SLAB	HIDDEN (4)	

WINDOW SCHEDULE						
NUMBER	QTY	SIZE	R/O	EGRESS	DESCRIPTION	LINTEL
W01	1	310811	46 1/2"X41 1/2"	YES	SINGLE HUNG	
W02	3	3430	41"X31 1/2"	YES	FIXED GLASS	
W03	2	31811	46"X12 1/2"	YES	FIXED GLASS	
W04	1	40110	48 1/2"X22 1/2"	YES	FIXED GLASS	
W05	3	44511	52 5/8"X11 1/2"	YES	SINGLE HUNG	


WIN DOOR SCHED

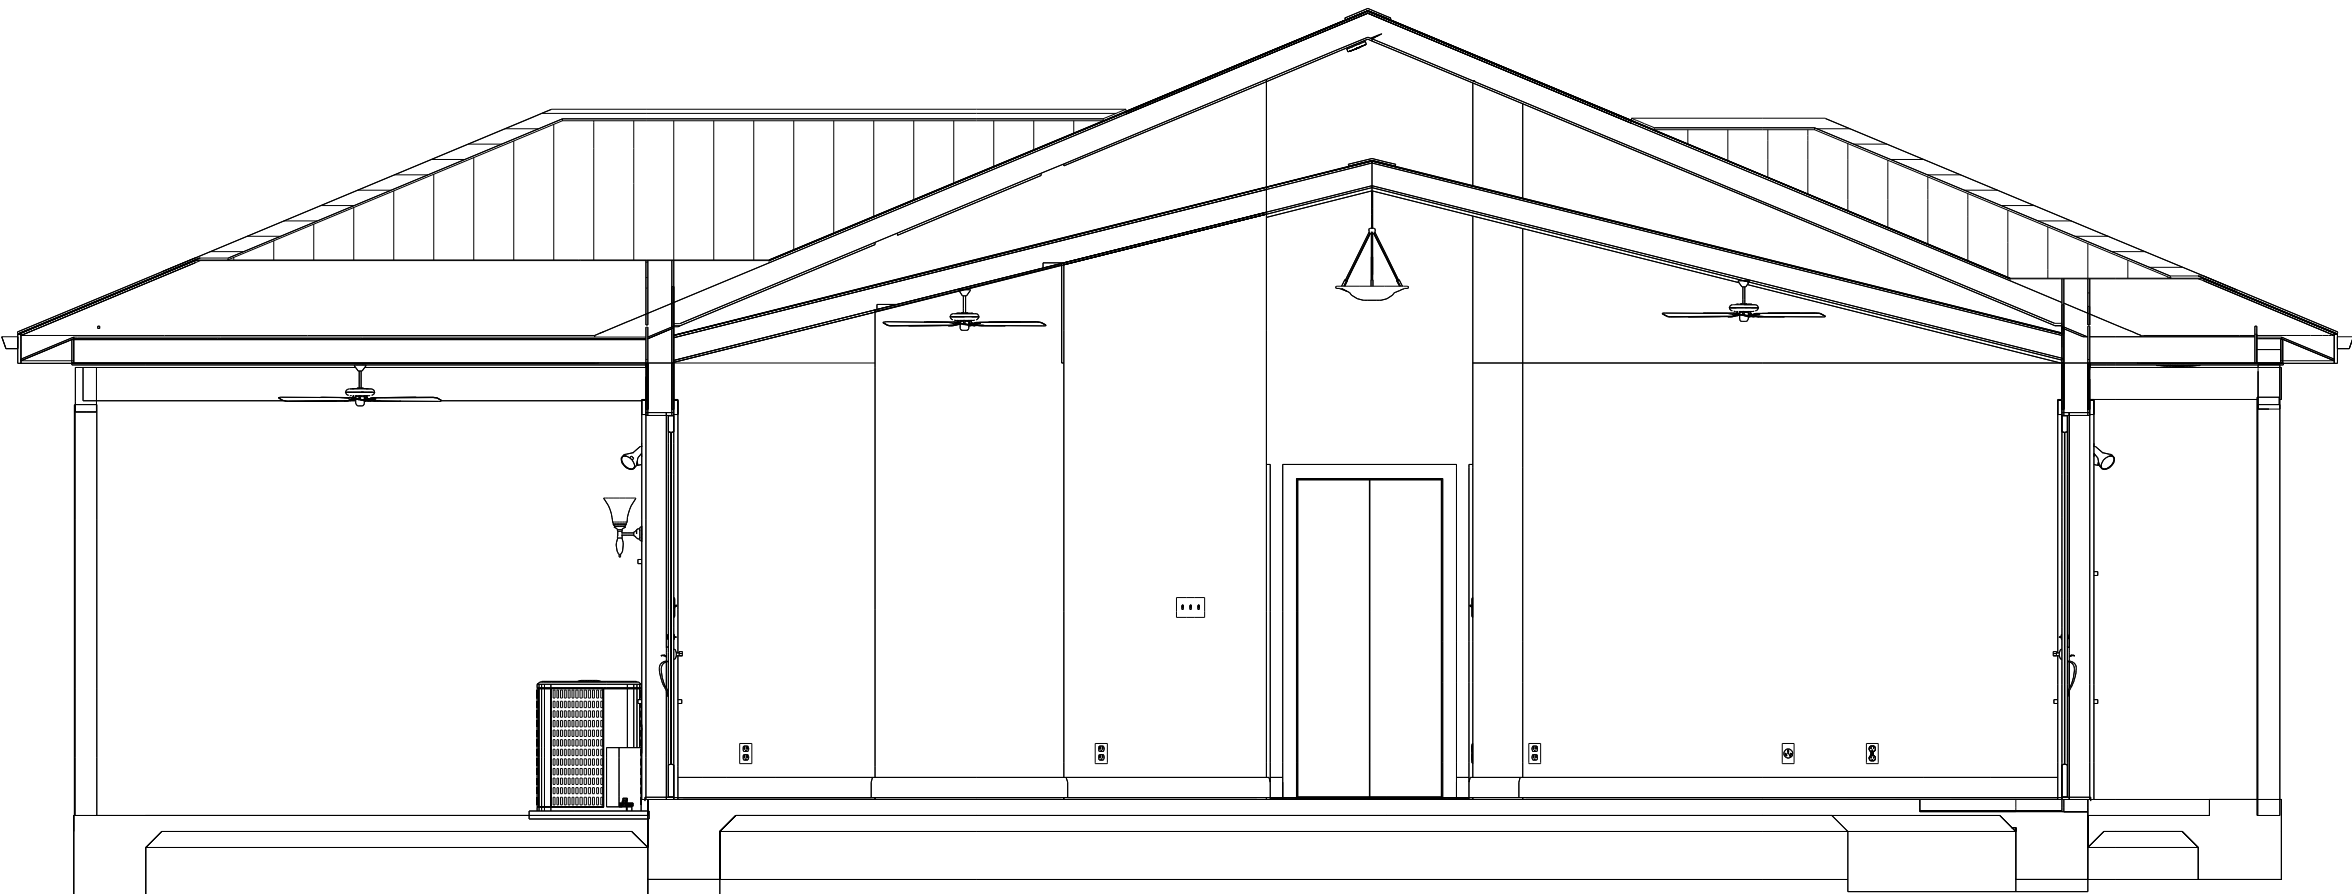


CROSS ROOF PITCH AND CEILING HT W/ VAULT

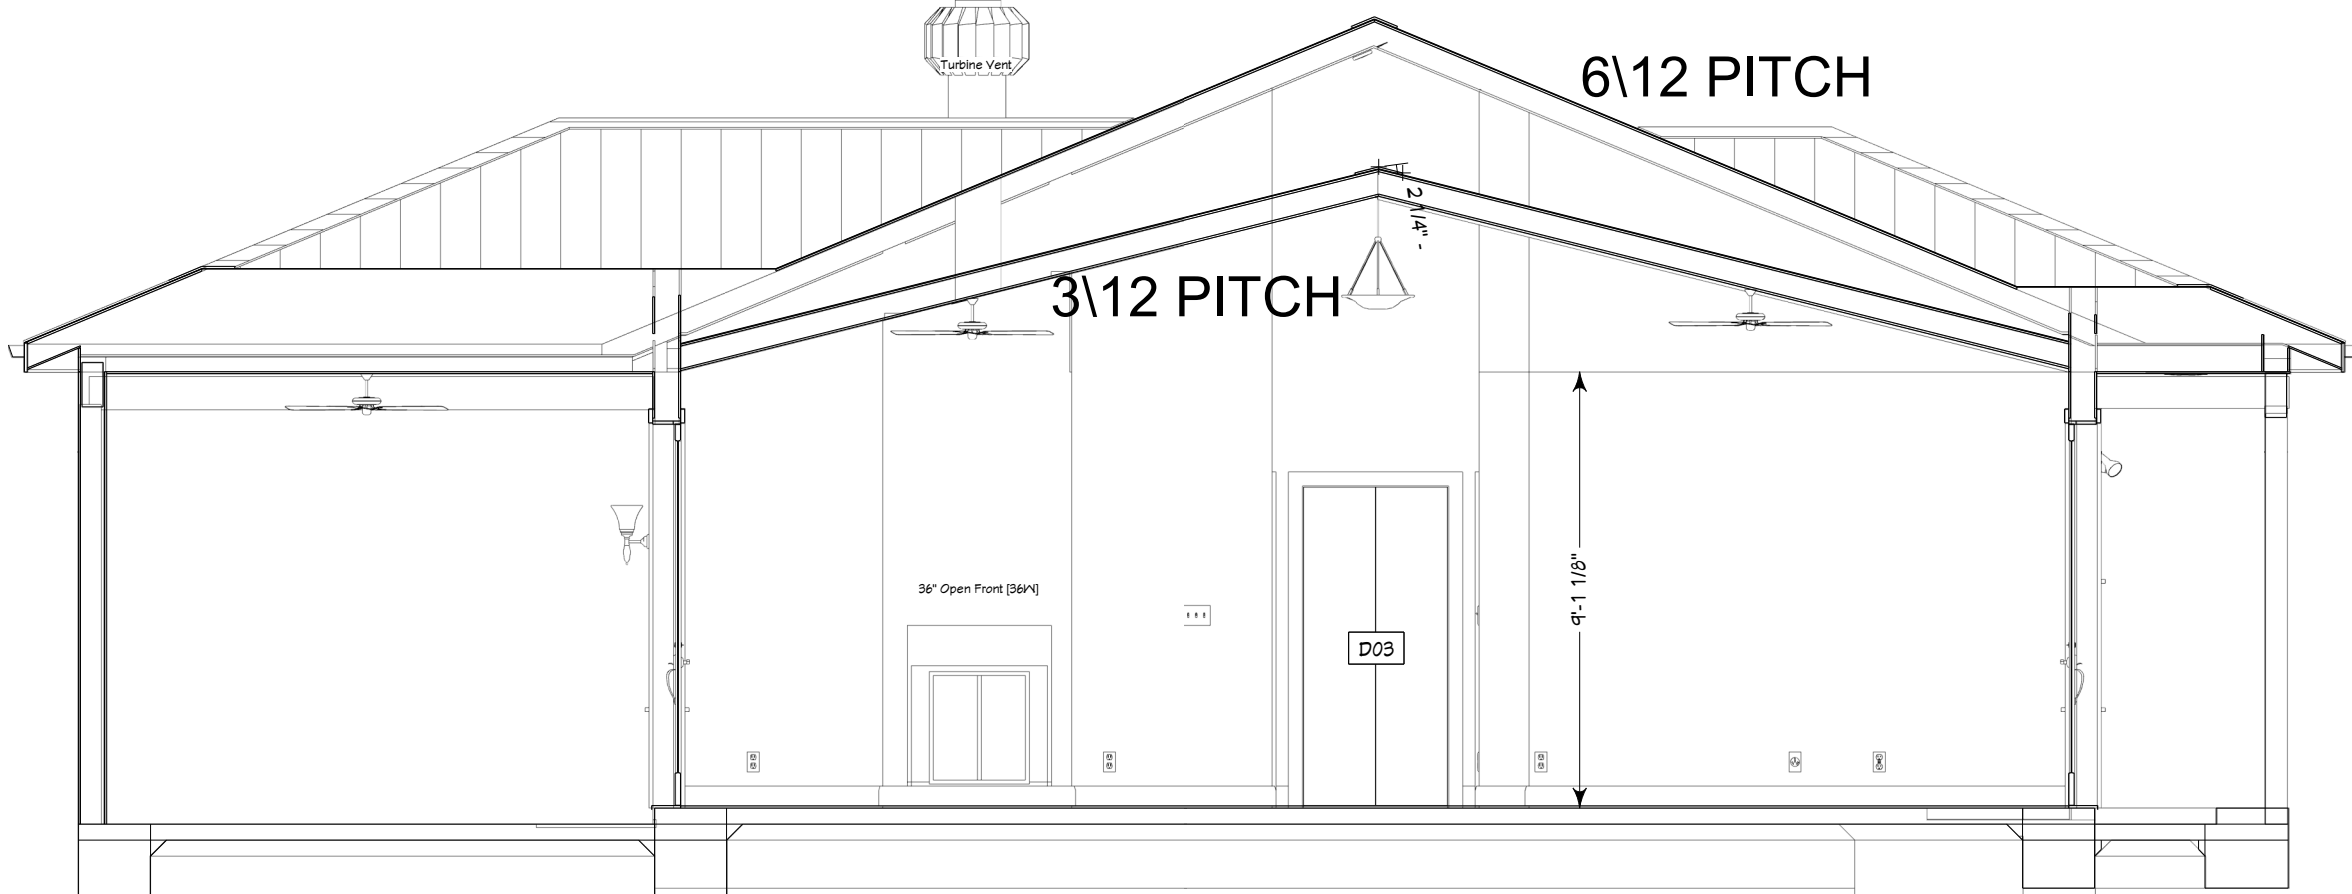

CROSS SECTION

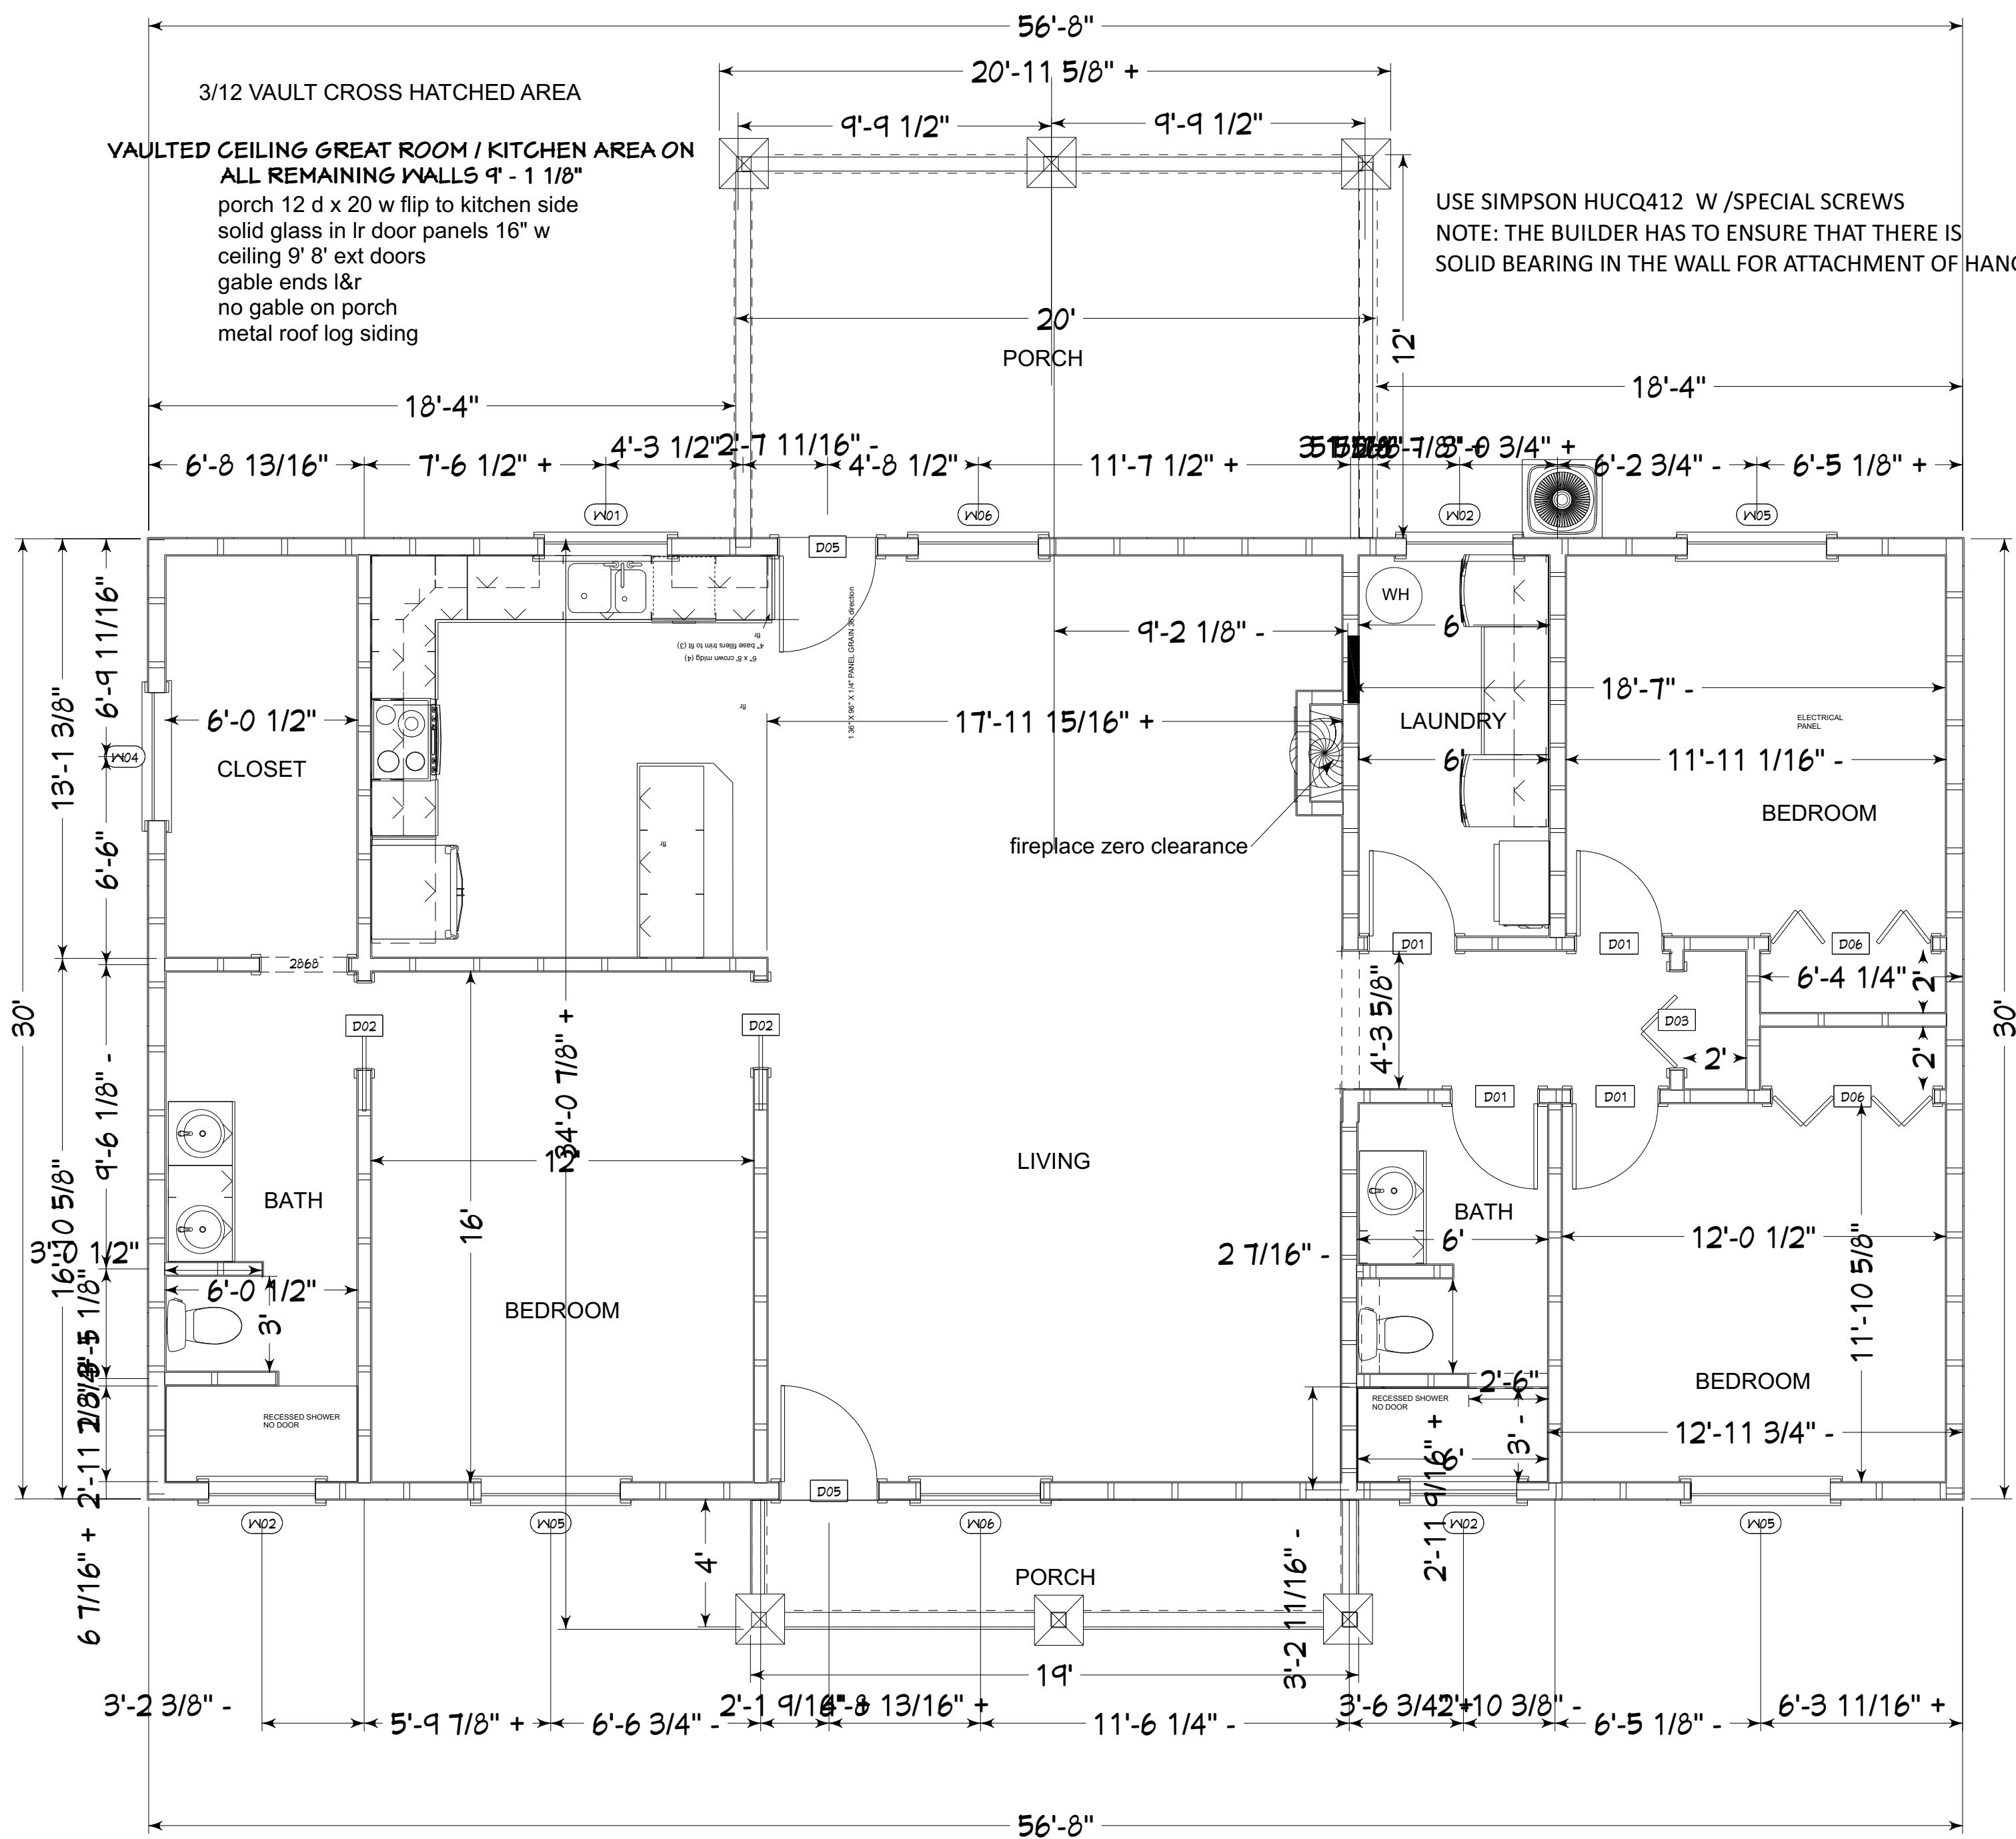

1st Floor

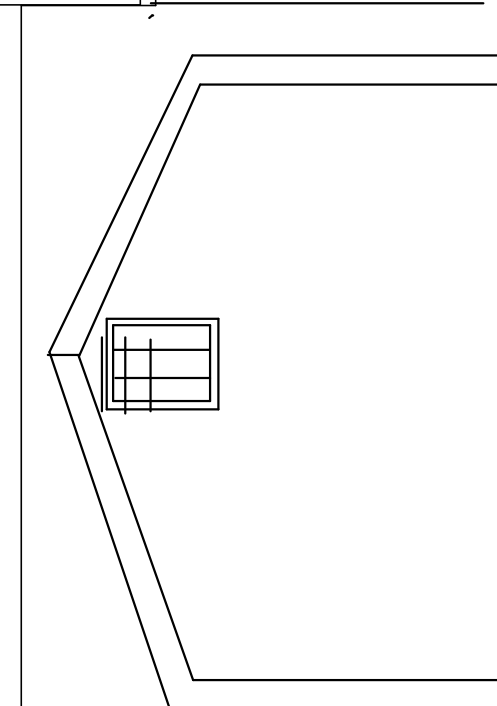

JOB TYPE
DATE:
REVISION #

NEW HOME


NAME:
ADDRESS:
PHONE:

SCALE:
UNLESS NOTED
1/4" = 1' - 0"




3/12 VAULT CROSS HATCHED AREA
VAULTED CEILING GREAT ROOM / KITCHEN AREA ON
ALL REMAINING WALLS 4" - 1 1/8"
porch 12 d x 20 w flip to kitchen side
solid glass in lr door panels 16" w
ceiling 9' 8" ext doors
gable ends l&r
no gable on porch
metal roof log siding


USE SIMPSON HUCQ412 W /SPECIAL SCREWS
NOTE: THE BUILDER HAS TO ENSURE THAT THERE IS
SOLID BEARING IN THE WALL FOR ATTACHMENT OF HANGER

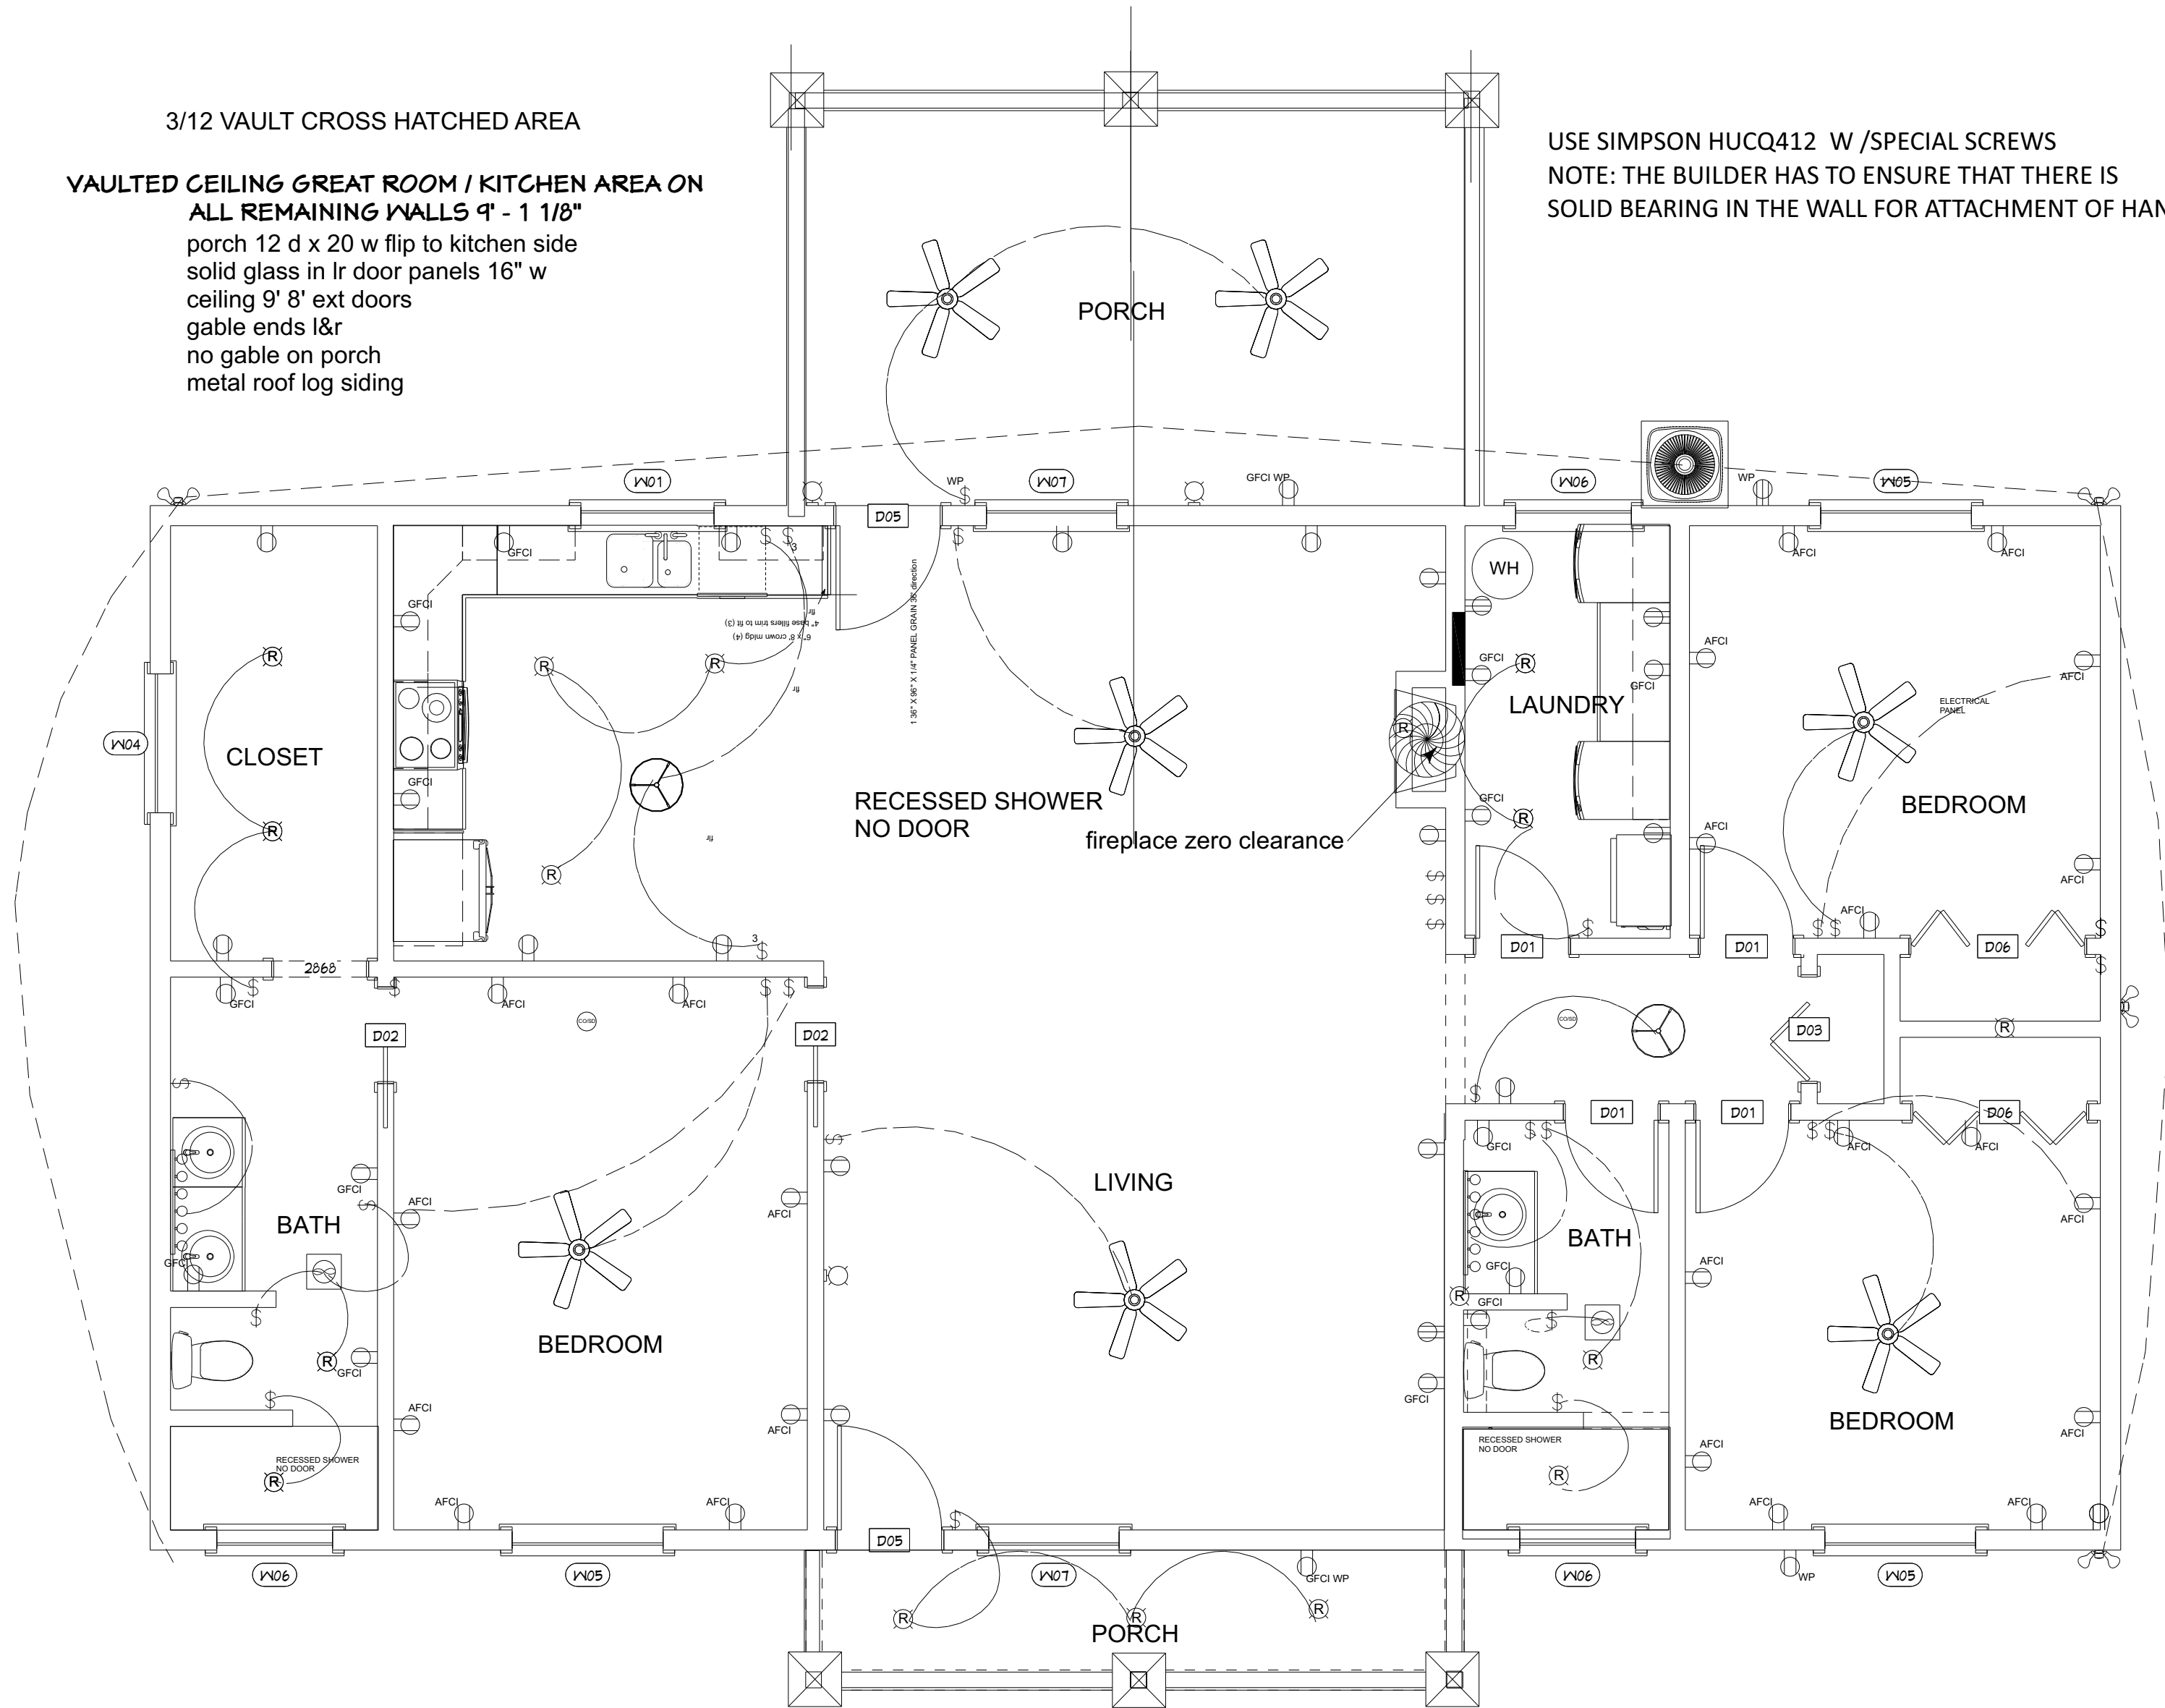


electrical

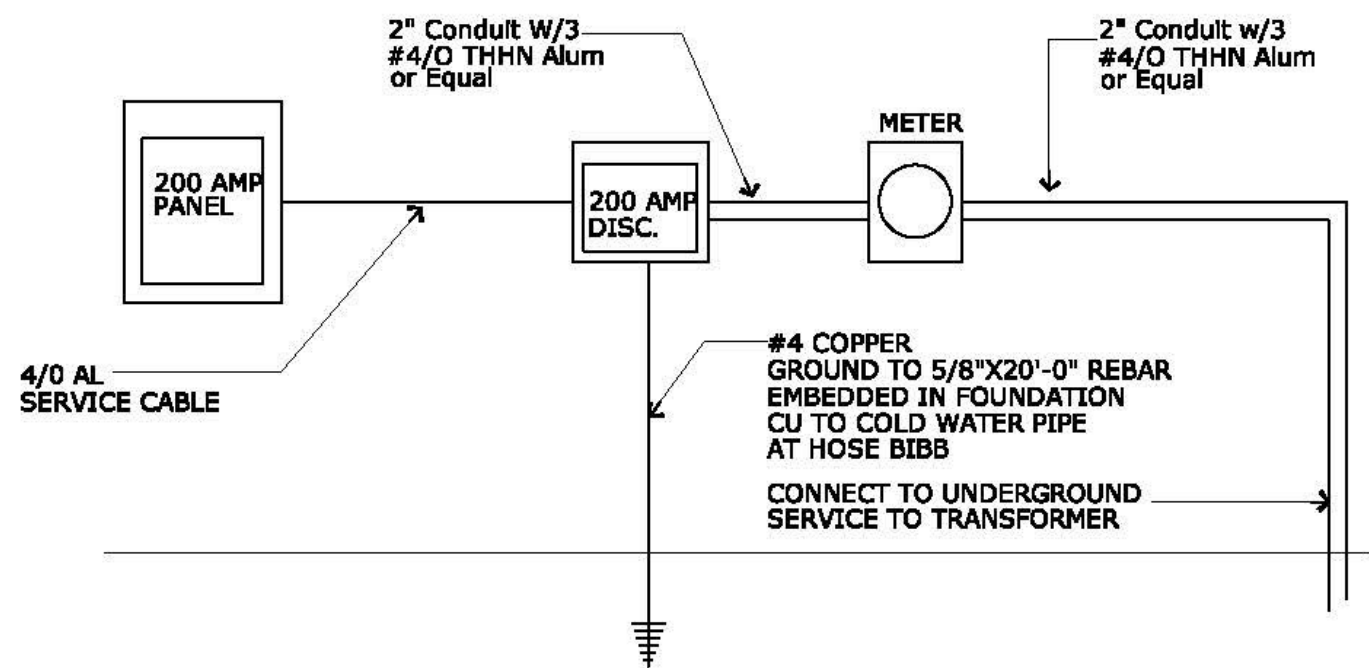


BELOW GROUND ELECTRICAL RISER






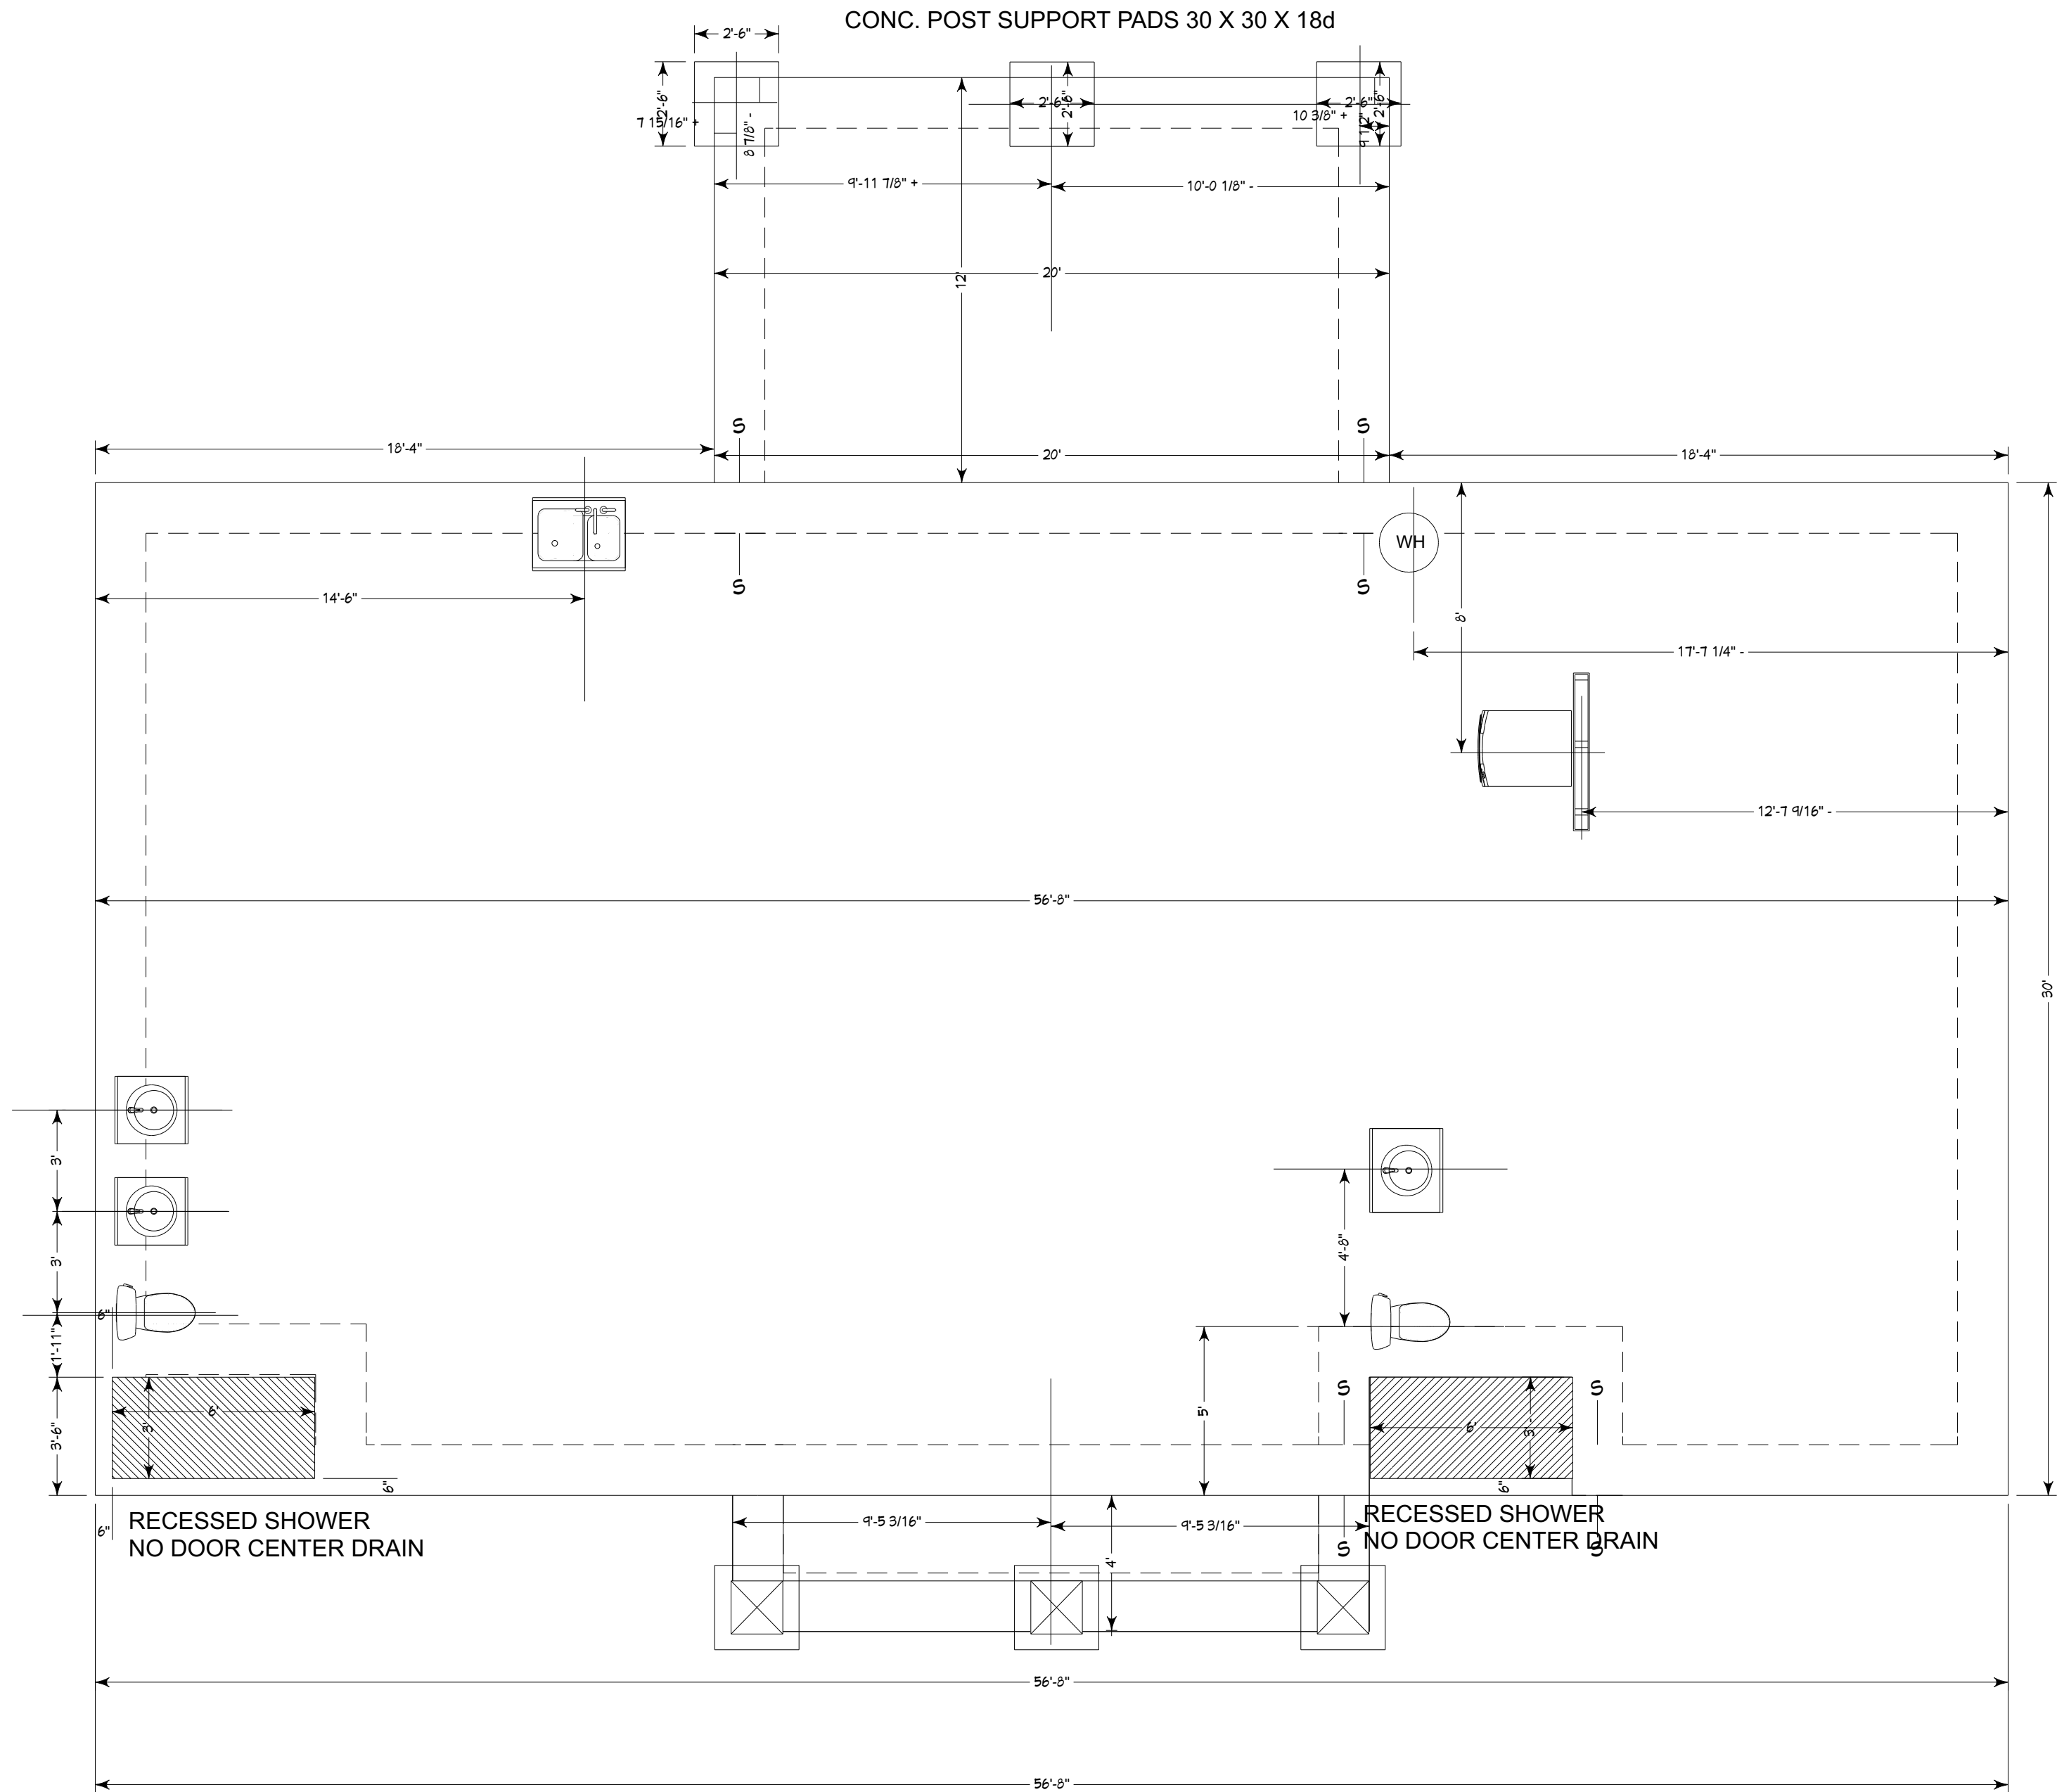


plumbing layout





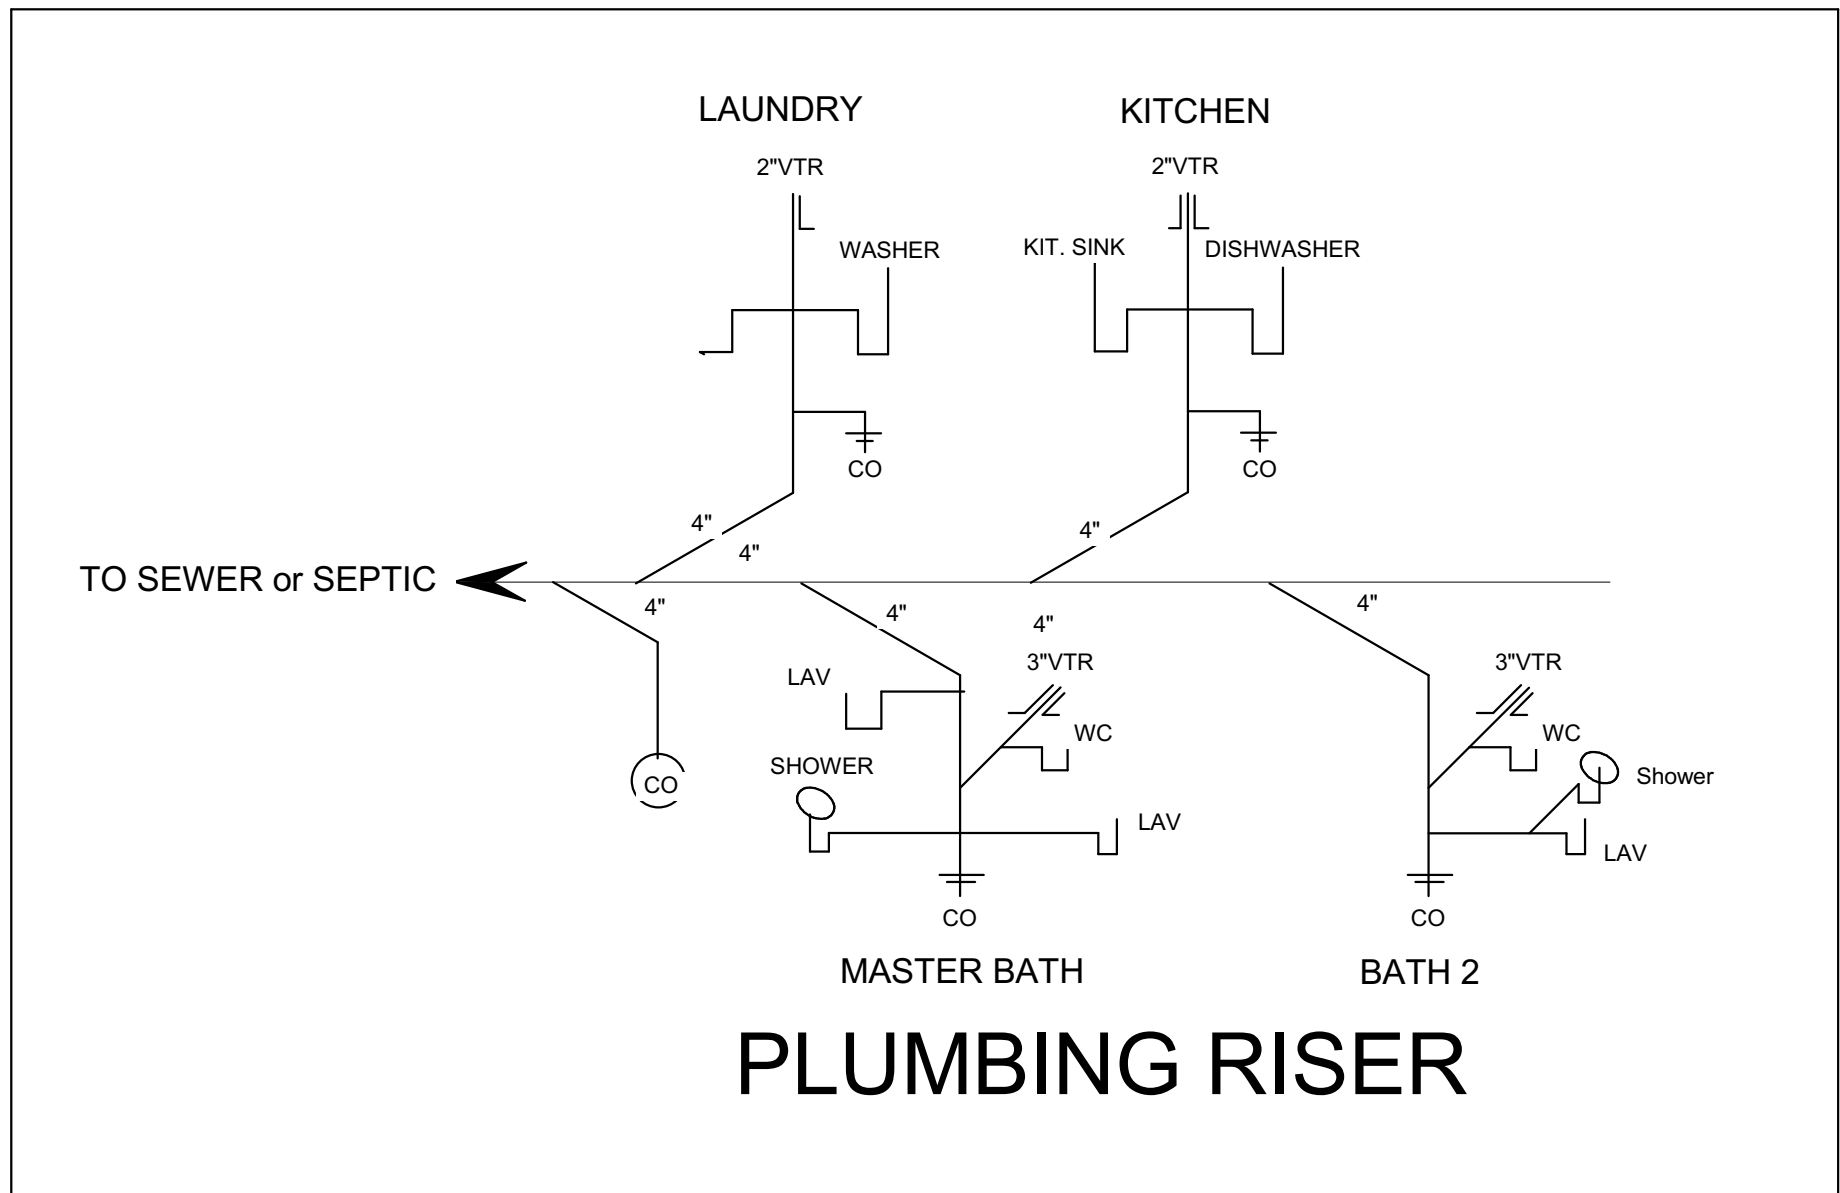


PLUMBING RISER

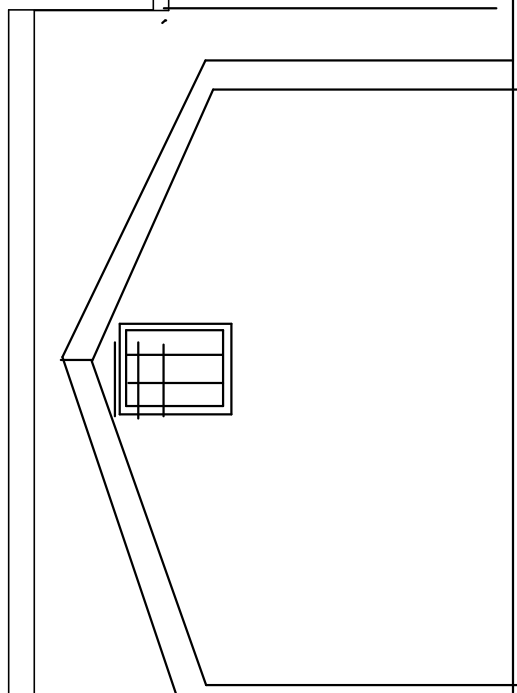

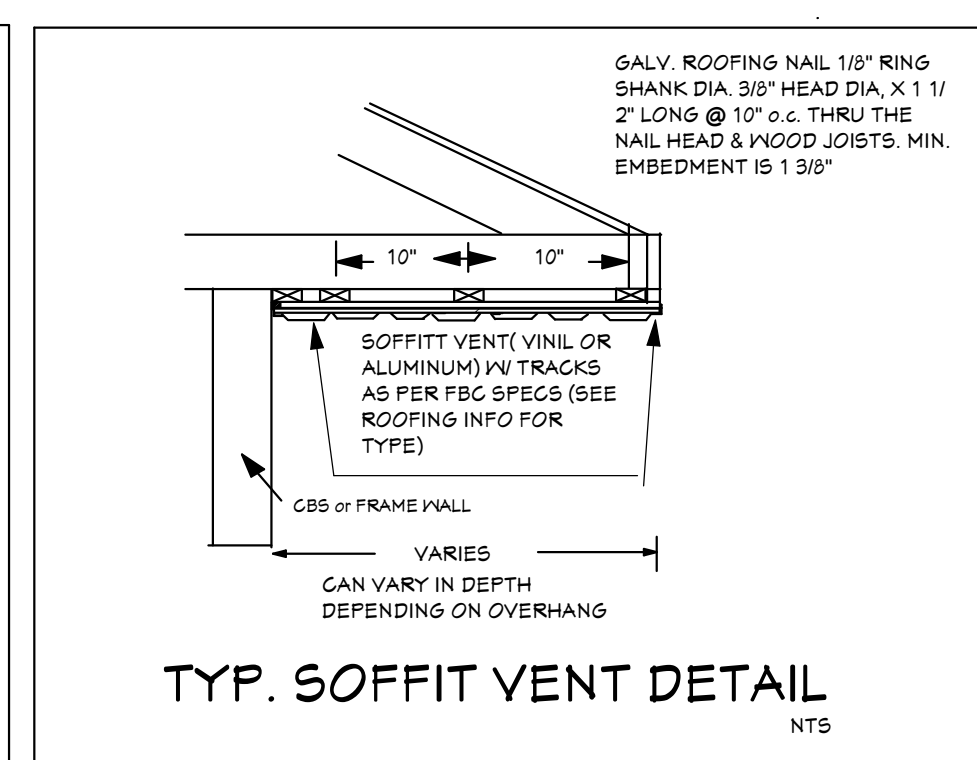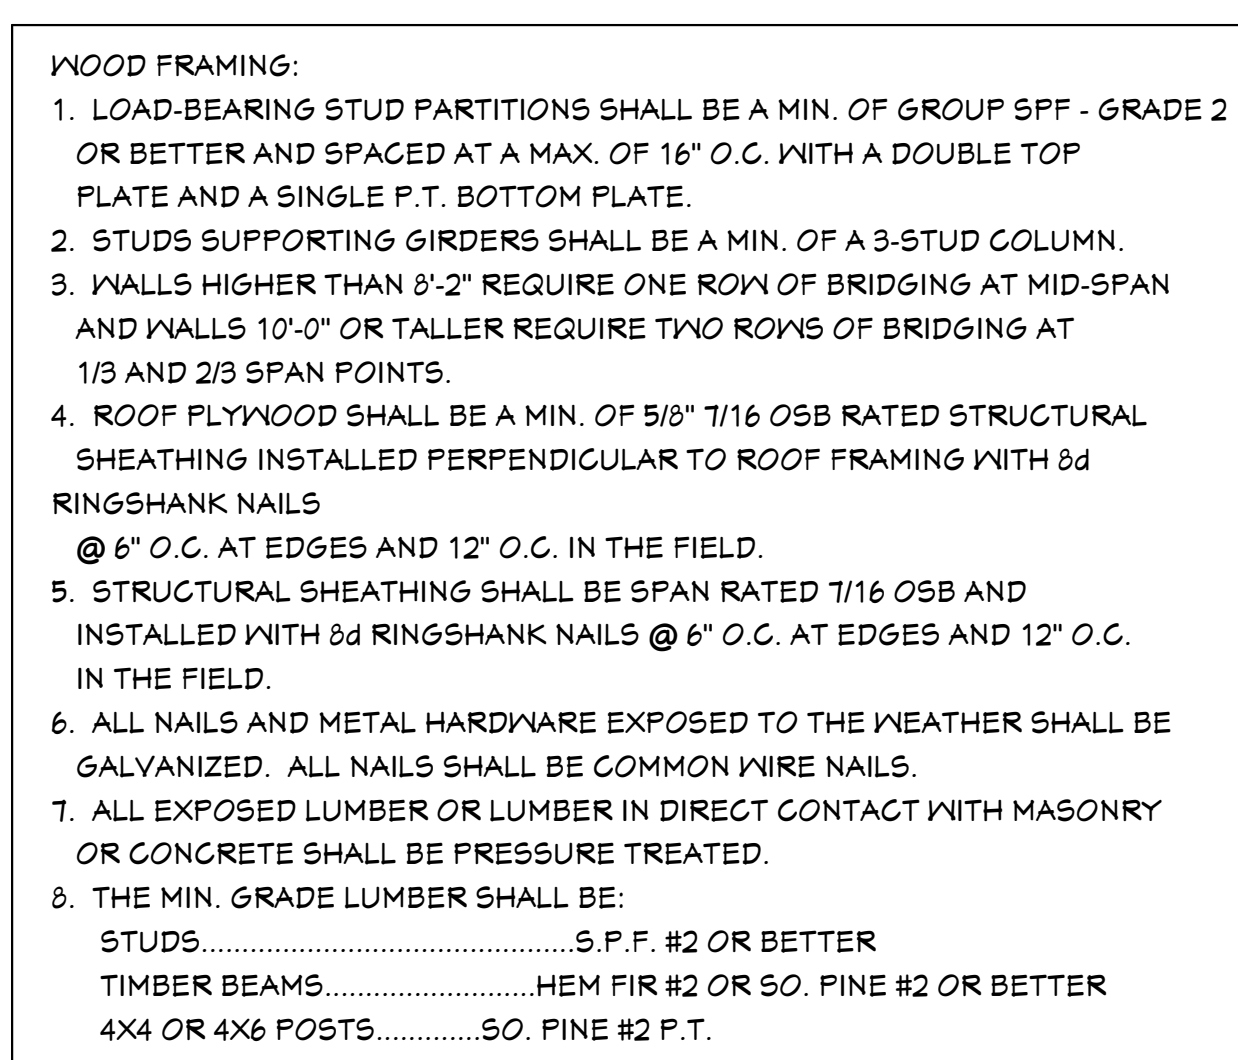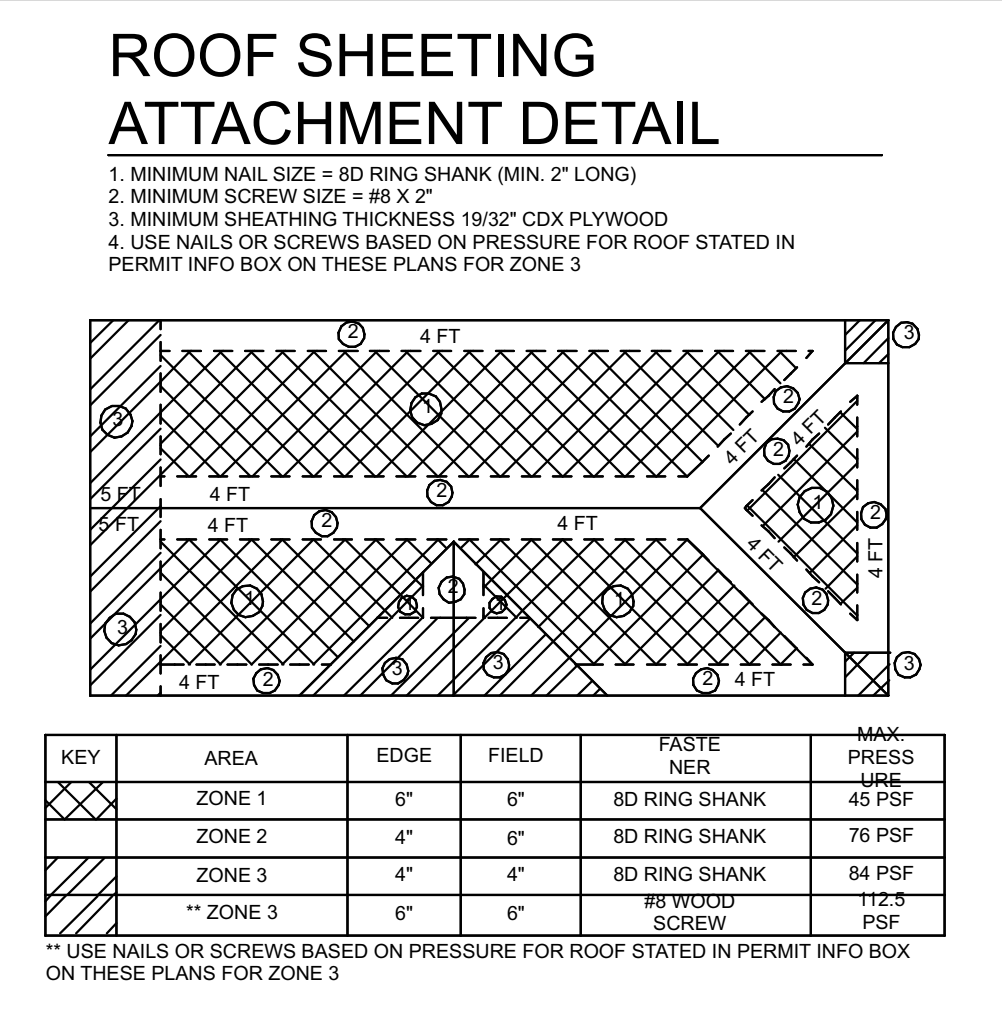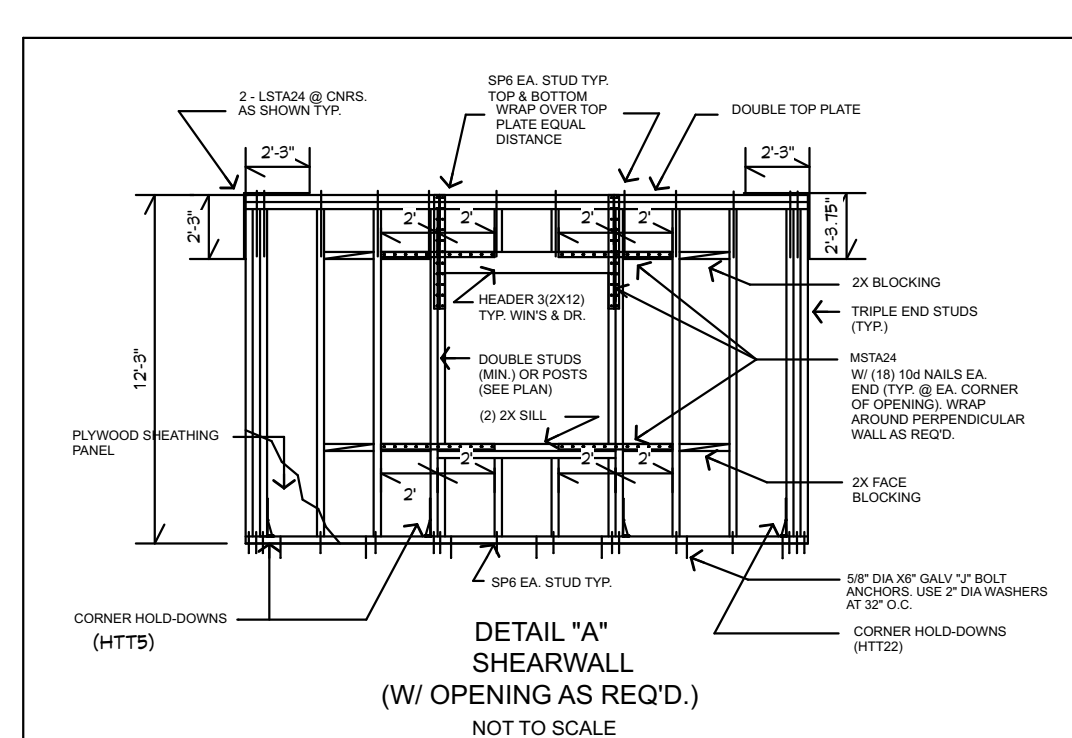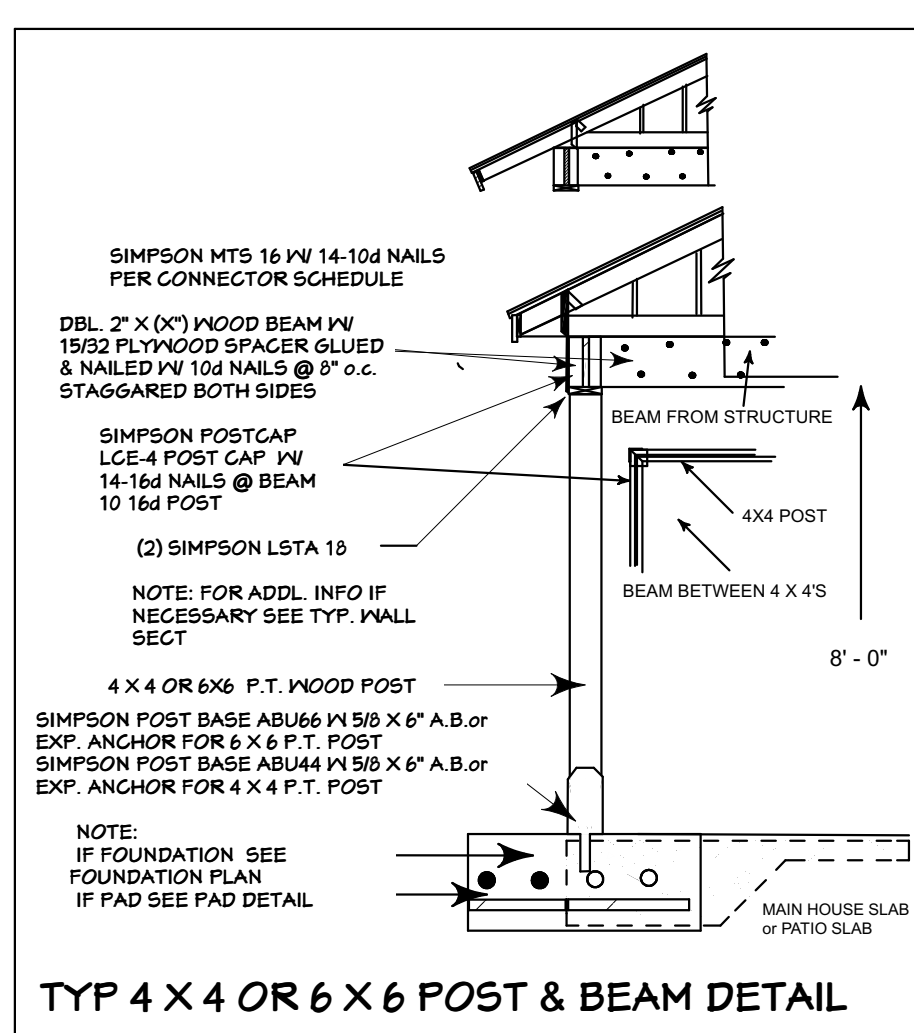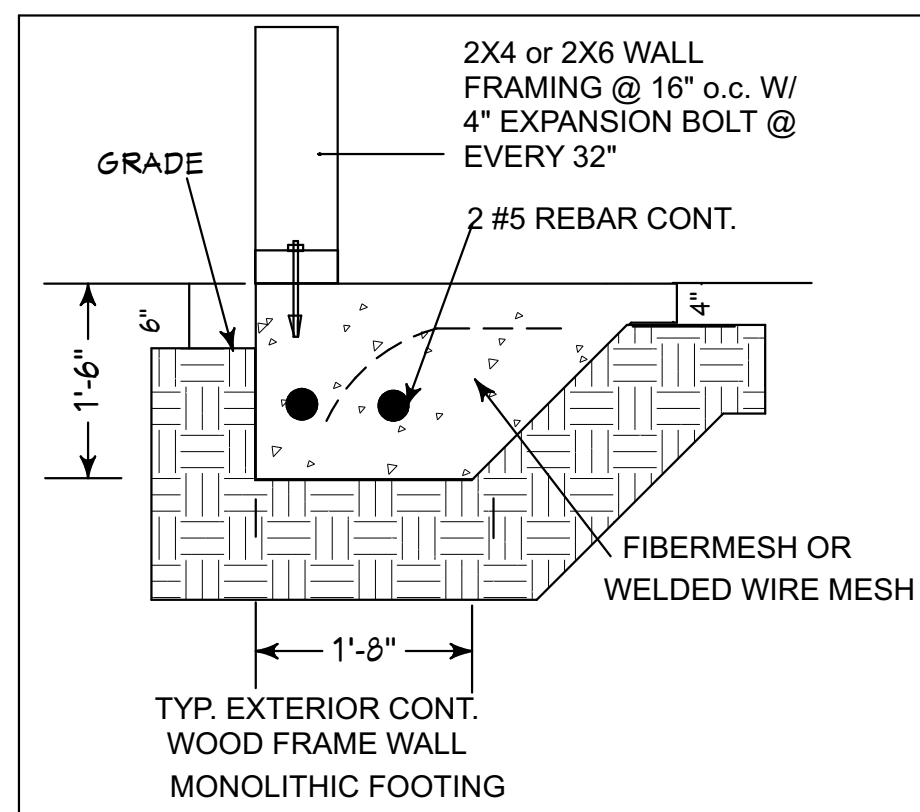

NOTE: WINDOWS & DOORS TO BE FLASHED AS PER FBCR 703.4
NOTE: WINDOWS LESS THAN 60" OFF FLOOR MUST BE
TEMPERED GLASS IN COMPLIANCE TO: FBC R308.4.1-R308.4.

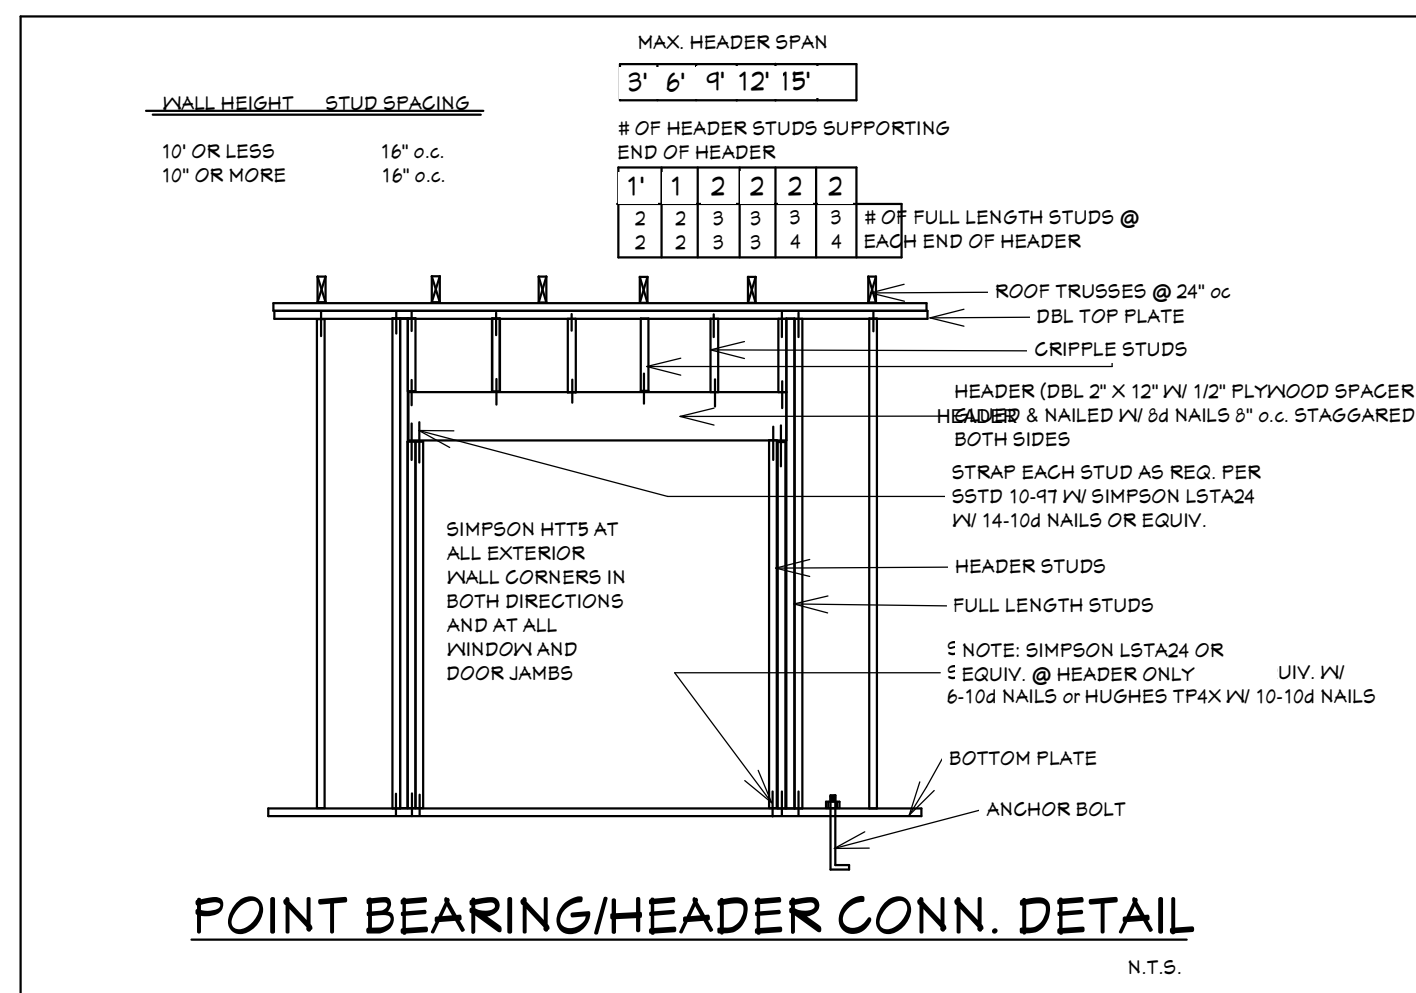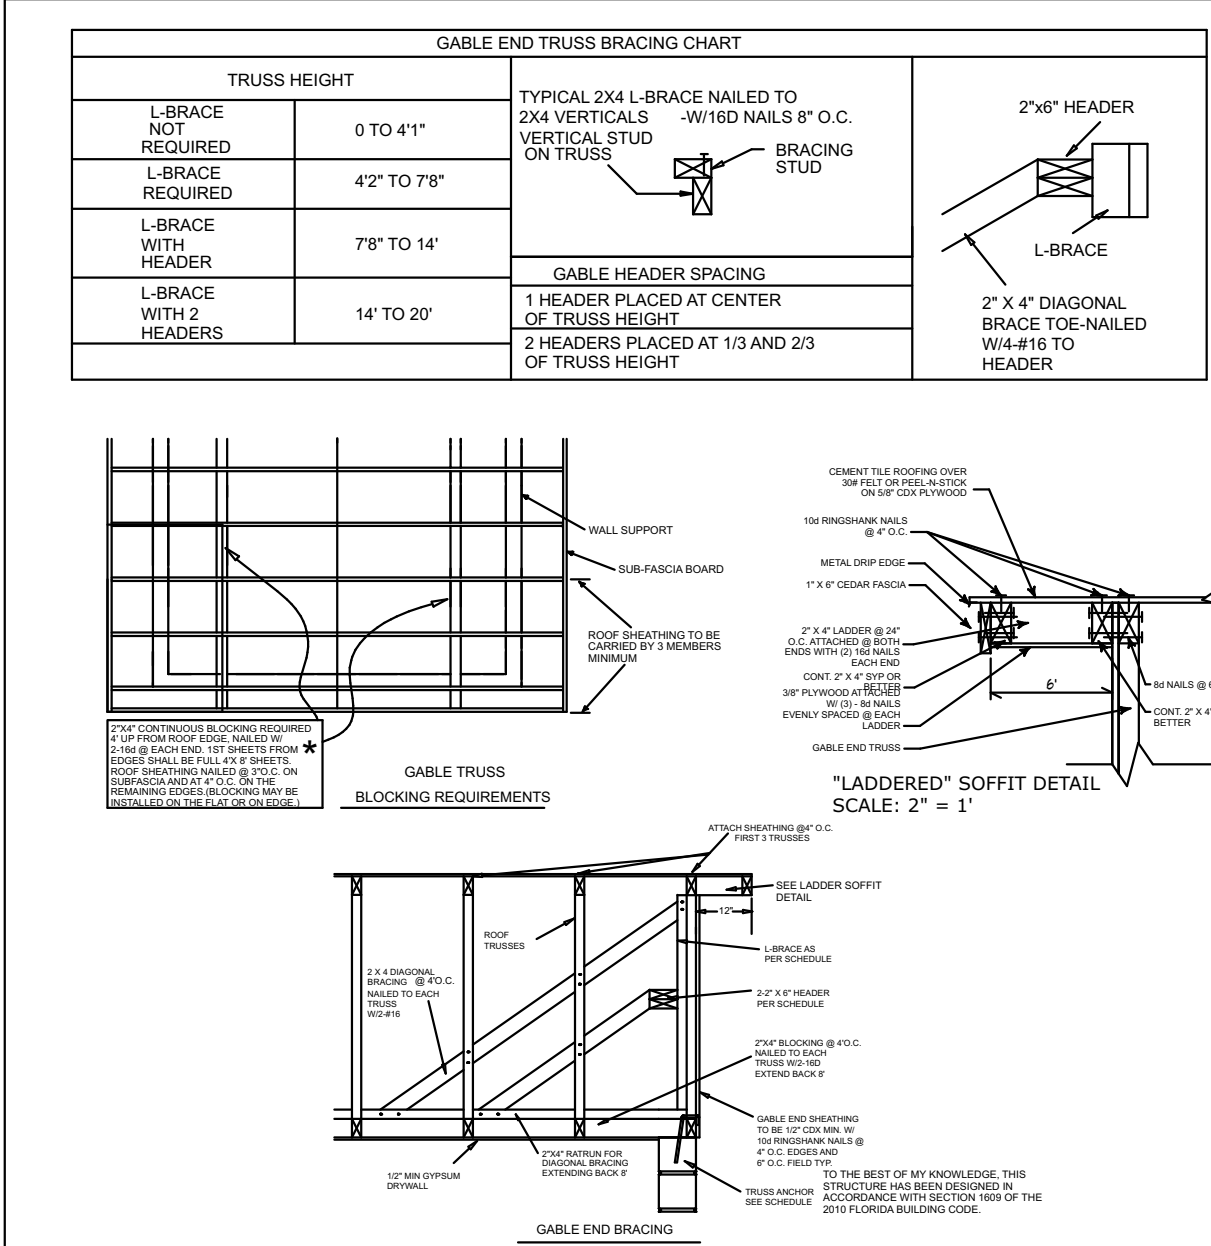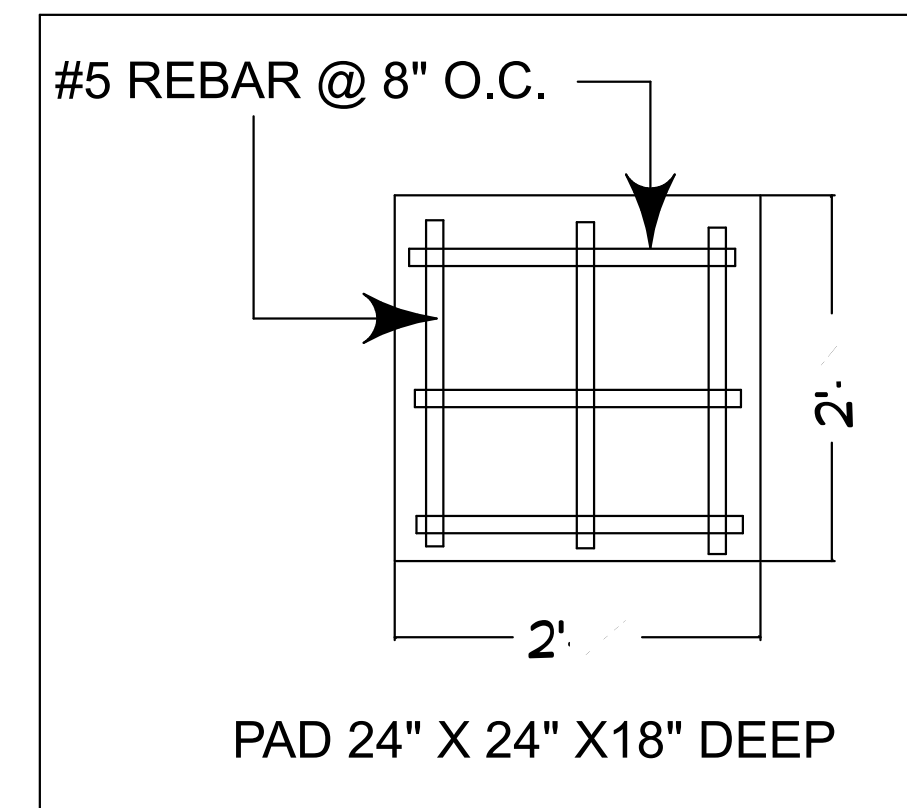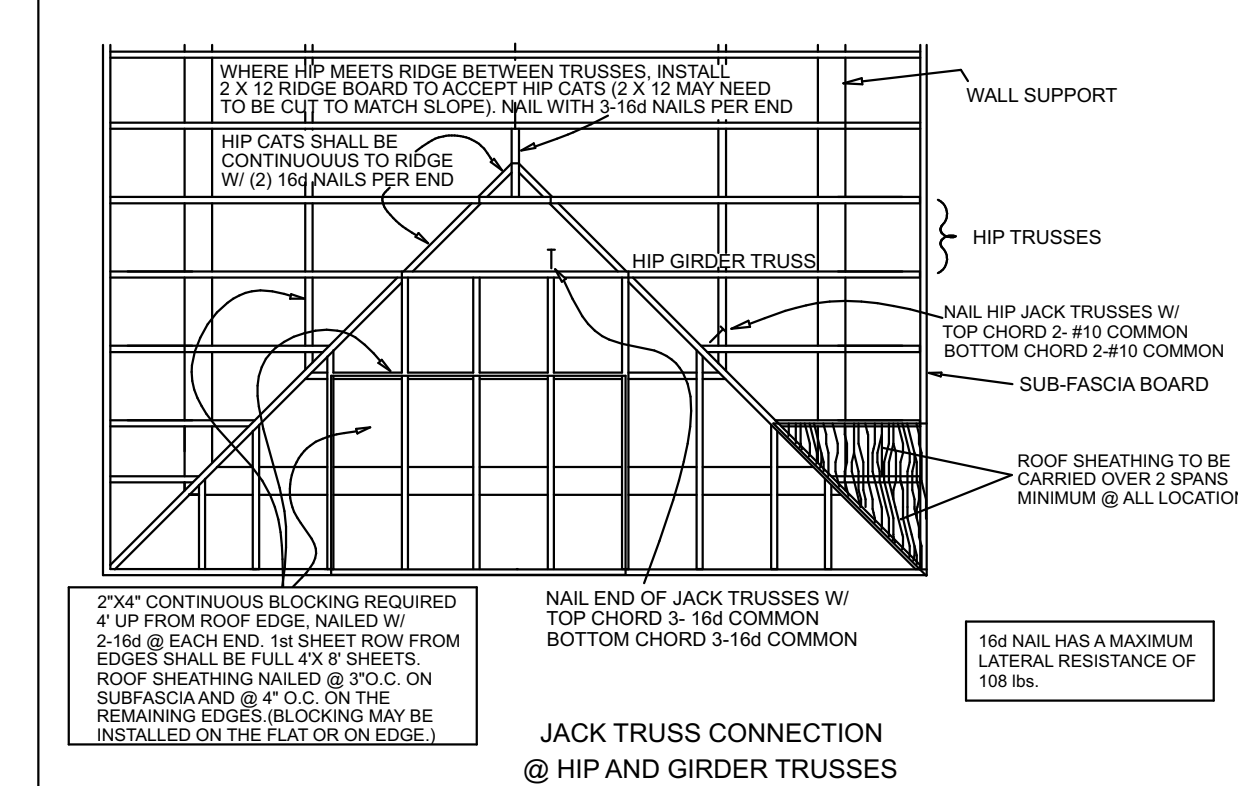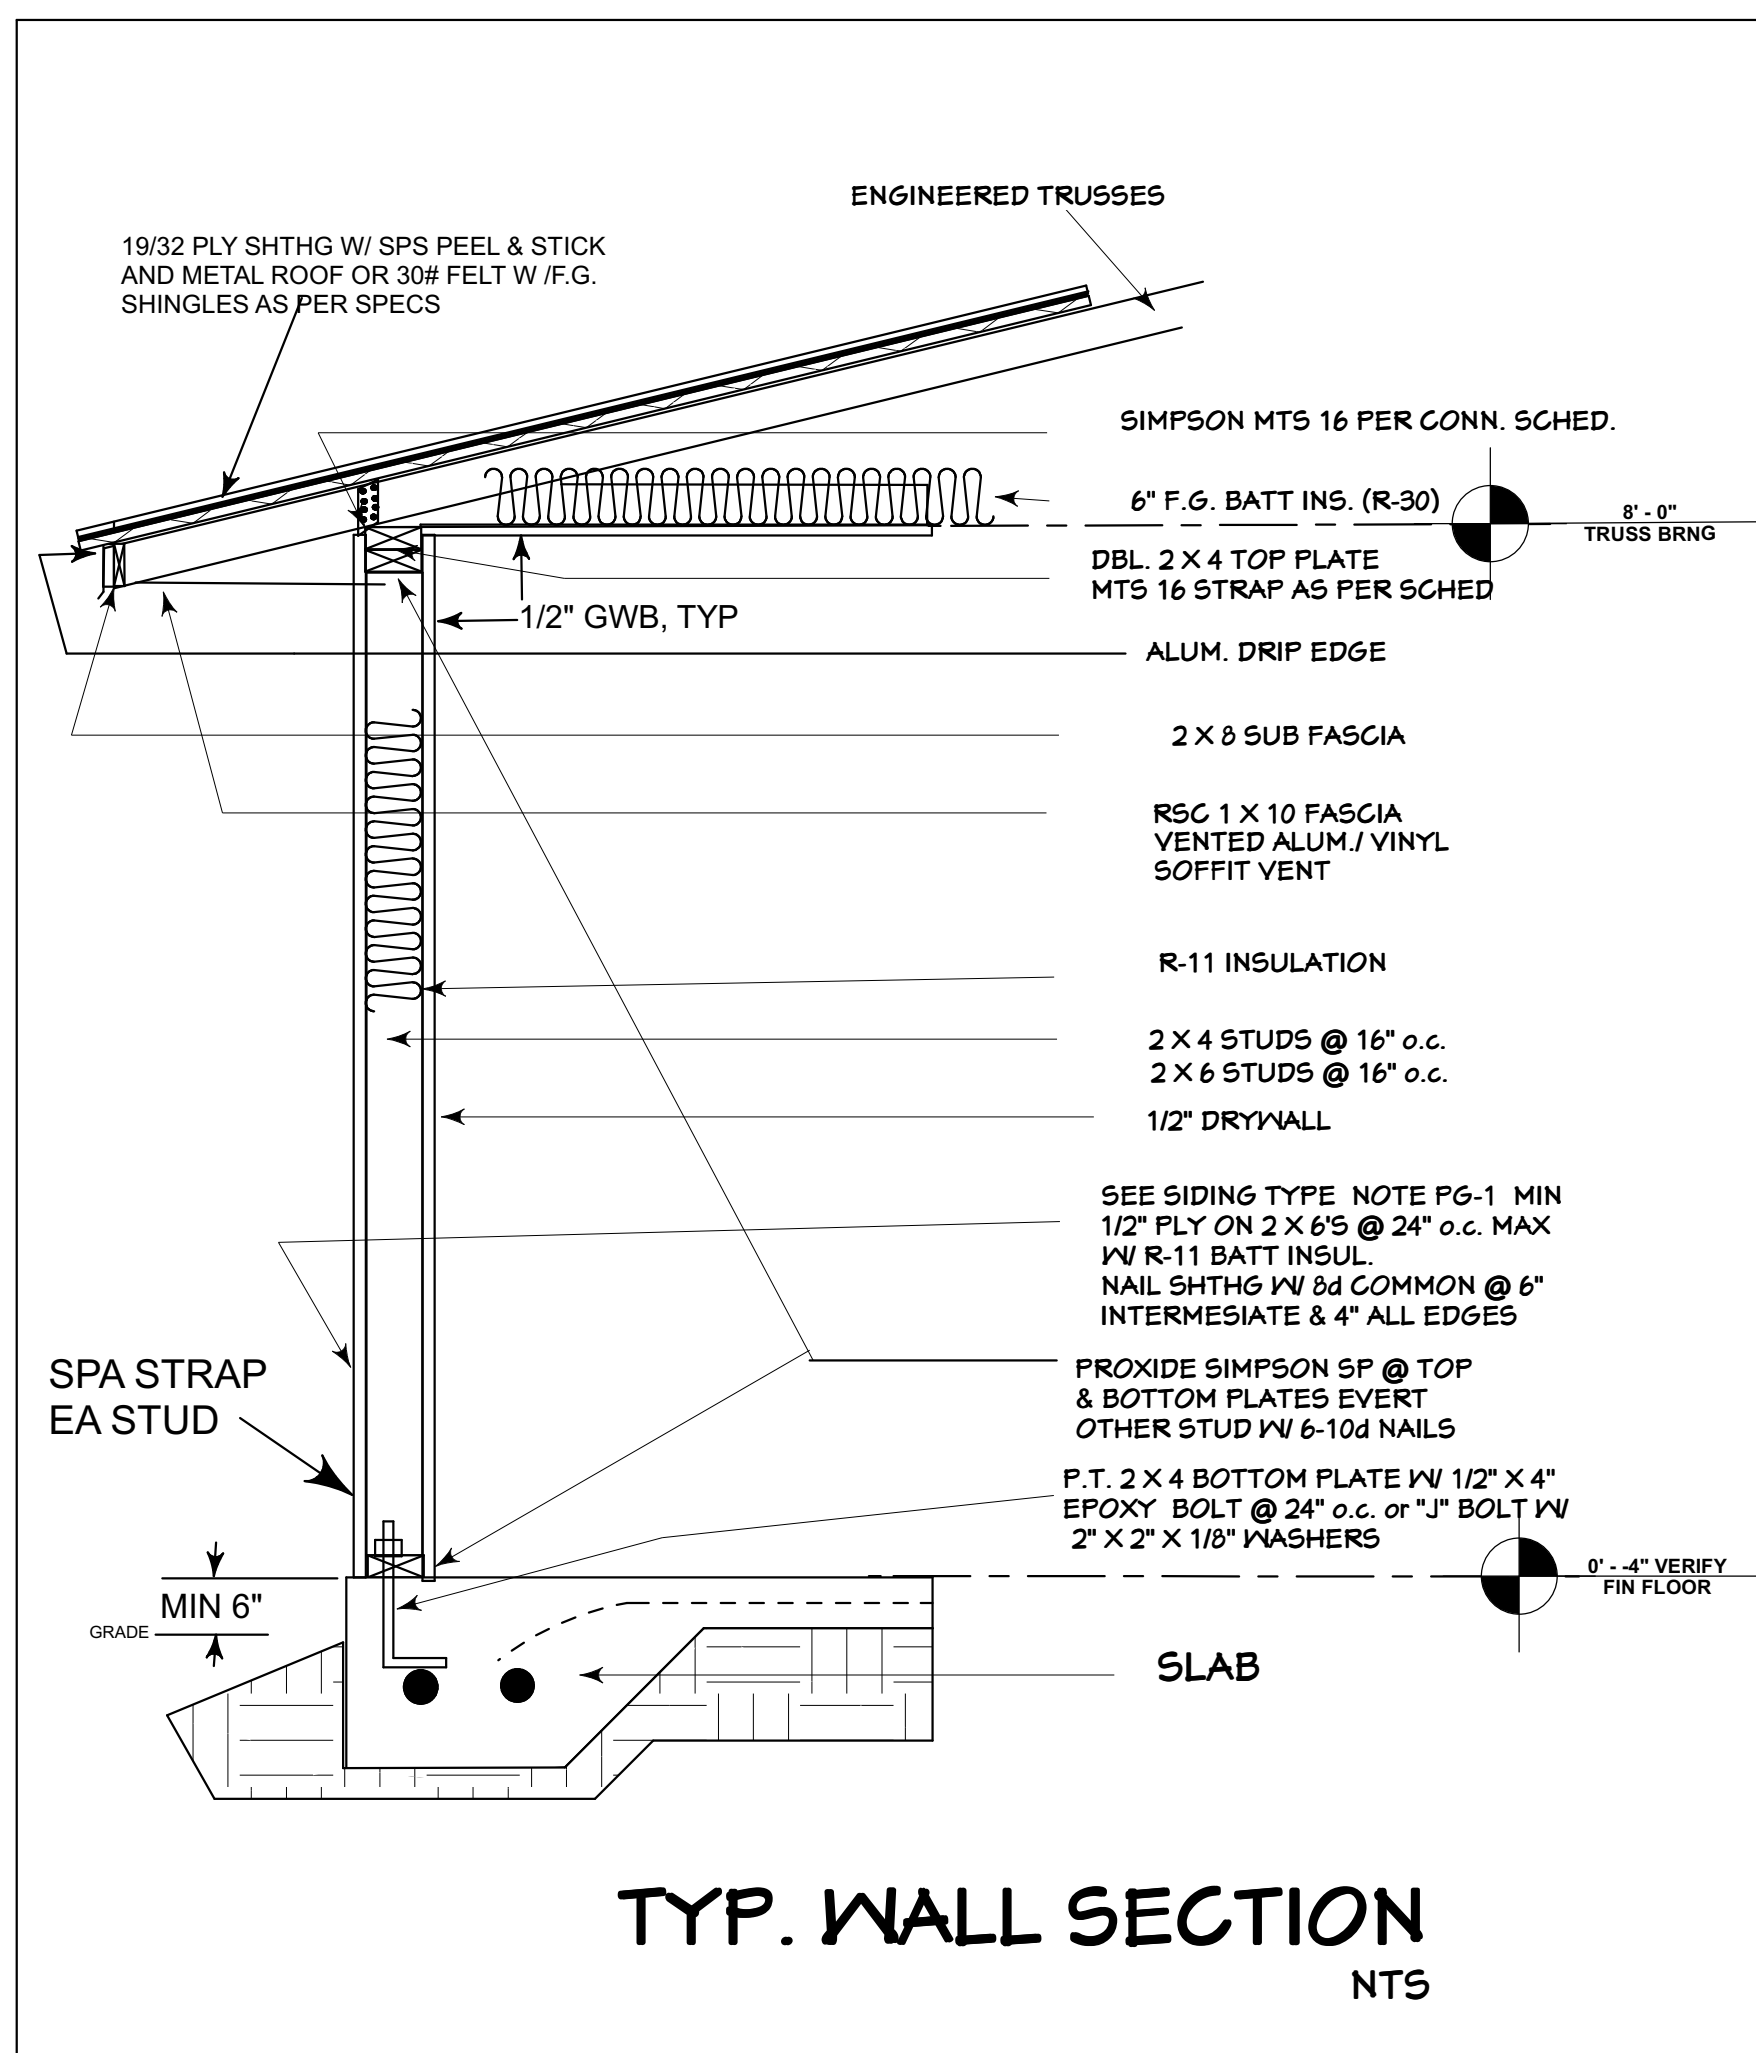

ENGINEERING CRITERIA

APPLICABLE CODE= FL BLDG CODE 2017, 6th ADDITION

PER CHAPTER 1609, USING ASCE 7-10

WIND SPEED= 170 mph V (ULT), 132 mph V (ASD)

WIND IMPORTANCE FACTOR= 1.0

RISK CATEGORY II

R3 (ENCLOSED)

EXPOSURE 'C'

INTERNAL PRESSURE COEFFICIENT- Gcp= 0.18

MEAN ROOF HEIGHT= 16 ft

LOADS:

FLOOR - 40 PSF

ROOF/DEAD - 20 PSF

ROOF/LIVE - 20 PSF

WALL - 18 PSF

IMPACT PROTECTION SHUTTERS IMPACT GL. ✓

MAXIMUM WINDOW PRESSURES:

MAX WINDOW PRESSURE=	+ 40.4 psf, - 54.1 psf
MAX DOOR PRESSURE=	+ 38.6 psf, - 50.5 psf
MAX SGD PRESSURE=	+ 36.1 psf, - 39.5 psf
MAX GAR. DOOR PRESSURE=	+ 35.6 psf, - 40.3 psf

